


BOH AISLEWAY DIMENSION PLAN

SCALE: 3/8" = 1'-0"

THIS DRAWING IS THE PROPERTY OF N. WASSERSTROM & SONS, INC. AND IS TO REMAIN IN THE POSSESSION OF OUR REPRESENTATIVE. UNLESS PERMISSION IS GIVEN BY N. WASSERSTROM & SONS, INC. AND MUST BE RETURNED WHEN REQUESTED.

FOR REFERENCE ONLY
 CAUTION: THESE DRAWINGS ARE FOR REFERENCE ONLY. FINAL RESPONSIBILITY FOR PLUMBING, ELECTRICAL & VENTILATION EQUIPMENT SHALL BE THE RESPONSIBILITY OF THE CONTRACTOR. THESE DRAWINGS ARE NOT INTENDED TO BE, NOR SHOULD THEY BE USED AS WORKING DRAWINGS. FOR ALL MECHANICAL REQUIREMENTS REFER TO THE APPROVED ARCHITECTURAL DRAWINGS. WASSERSTROM ASSUMES NO LIABILITY IN PROVIDING THESE DRAWINGS.

AMAIZE




CRITICAL DIMENSION AND ELEVATION MARKER PLAN

DATE: 01/29/2014
 SCALE: 3/8" = 1'-0"
 DRAWN: MJH
 DWG. NUMBER: 12120600

SHEET
K-100
 1 OF (7) SHEETS


FOR REFERENCE ONLY
CAUTION: THESE DRAWINGS ARE FOR REFERENCE ONLY. FINAL RESPONSIBILITY FOR PLUMBING, ELECTRICAL & VENTILATION EQUIPMENT SHALL BE THE RESPONSIBILITY OF THE CONTRACTOR. THESE DRAWINGS ARE NOT TO BE USED FOR CONSTRUCTION OF ANY MECHANICAL SYSTEMS. THESE DRAWINGS ARE NOT TO BE USED FOR ANY OTHER PURPOSES WITHOUT THE WRITTEN PERMISSION OF THE ARCHITECT. MECHANICAL REQUIREMENTS REFER TO THE APPROVED ARCHITECTURAL DRAWINGS. WATERSTROM ASSUMES NO LIABILITY IN REGARDING THESE DRAWINGS.

AMAIZE

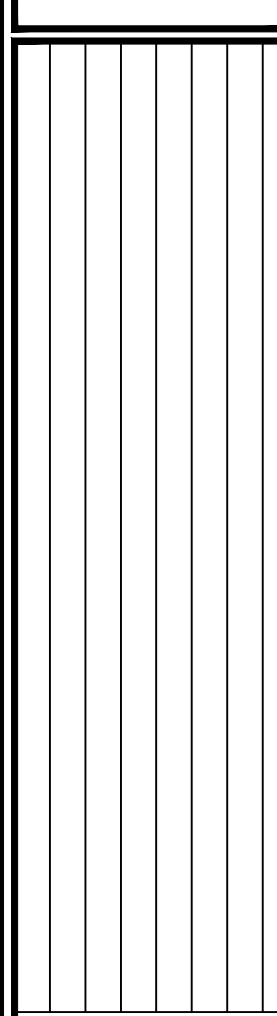

KITCHEN EQUIPMENT PLAN AND SCHEDULE

DATE: 01/29/2014
SCALE: 3/8" = 1'-0"
DRAWN: MJH
DWG. NUMBER: 12120600
SHEET: K-101
1 OF 7 SHEETS

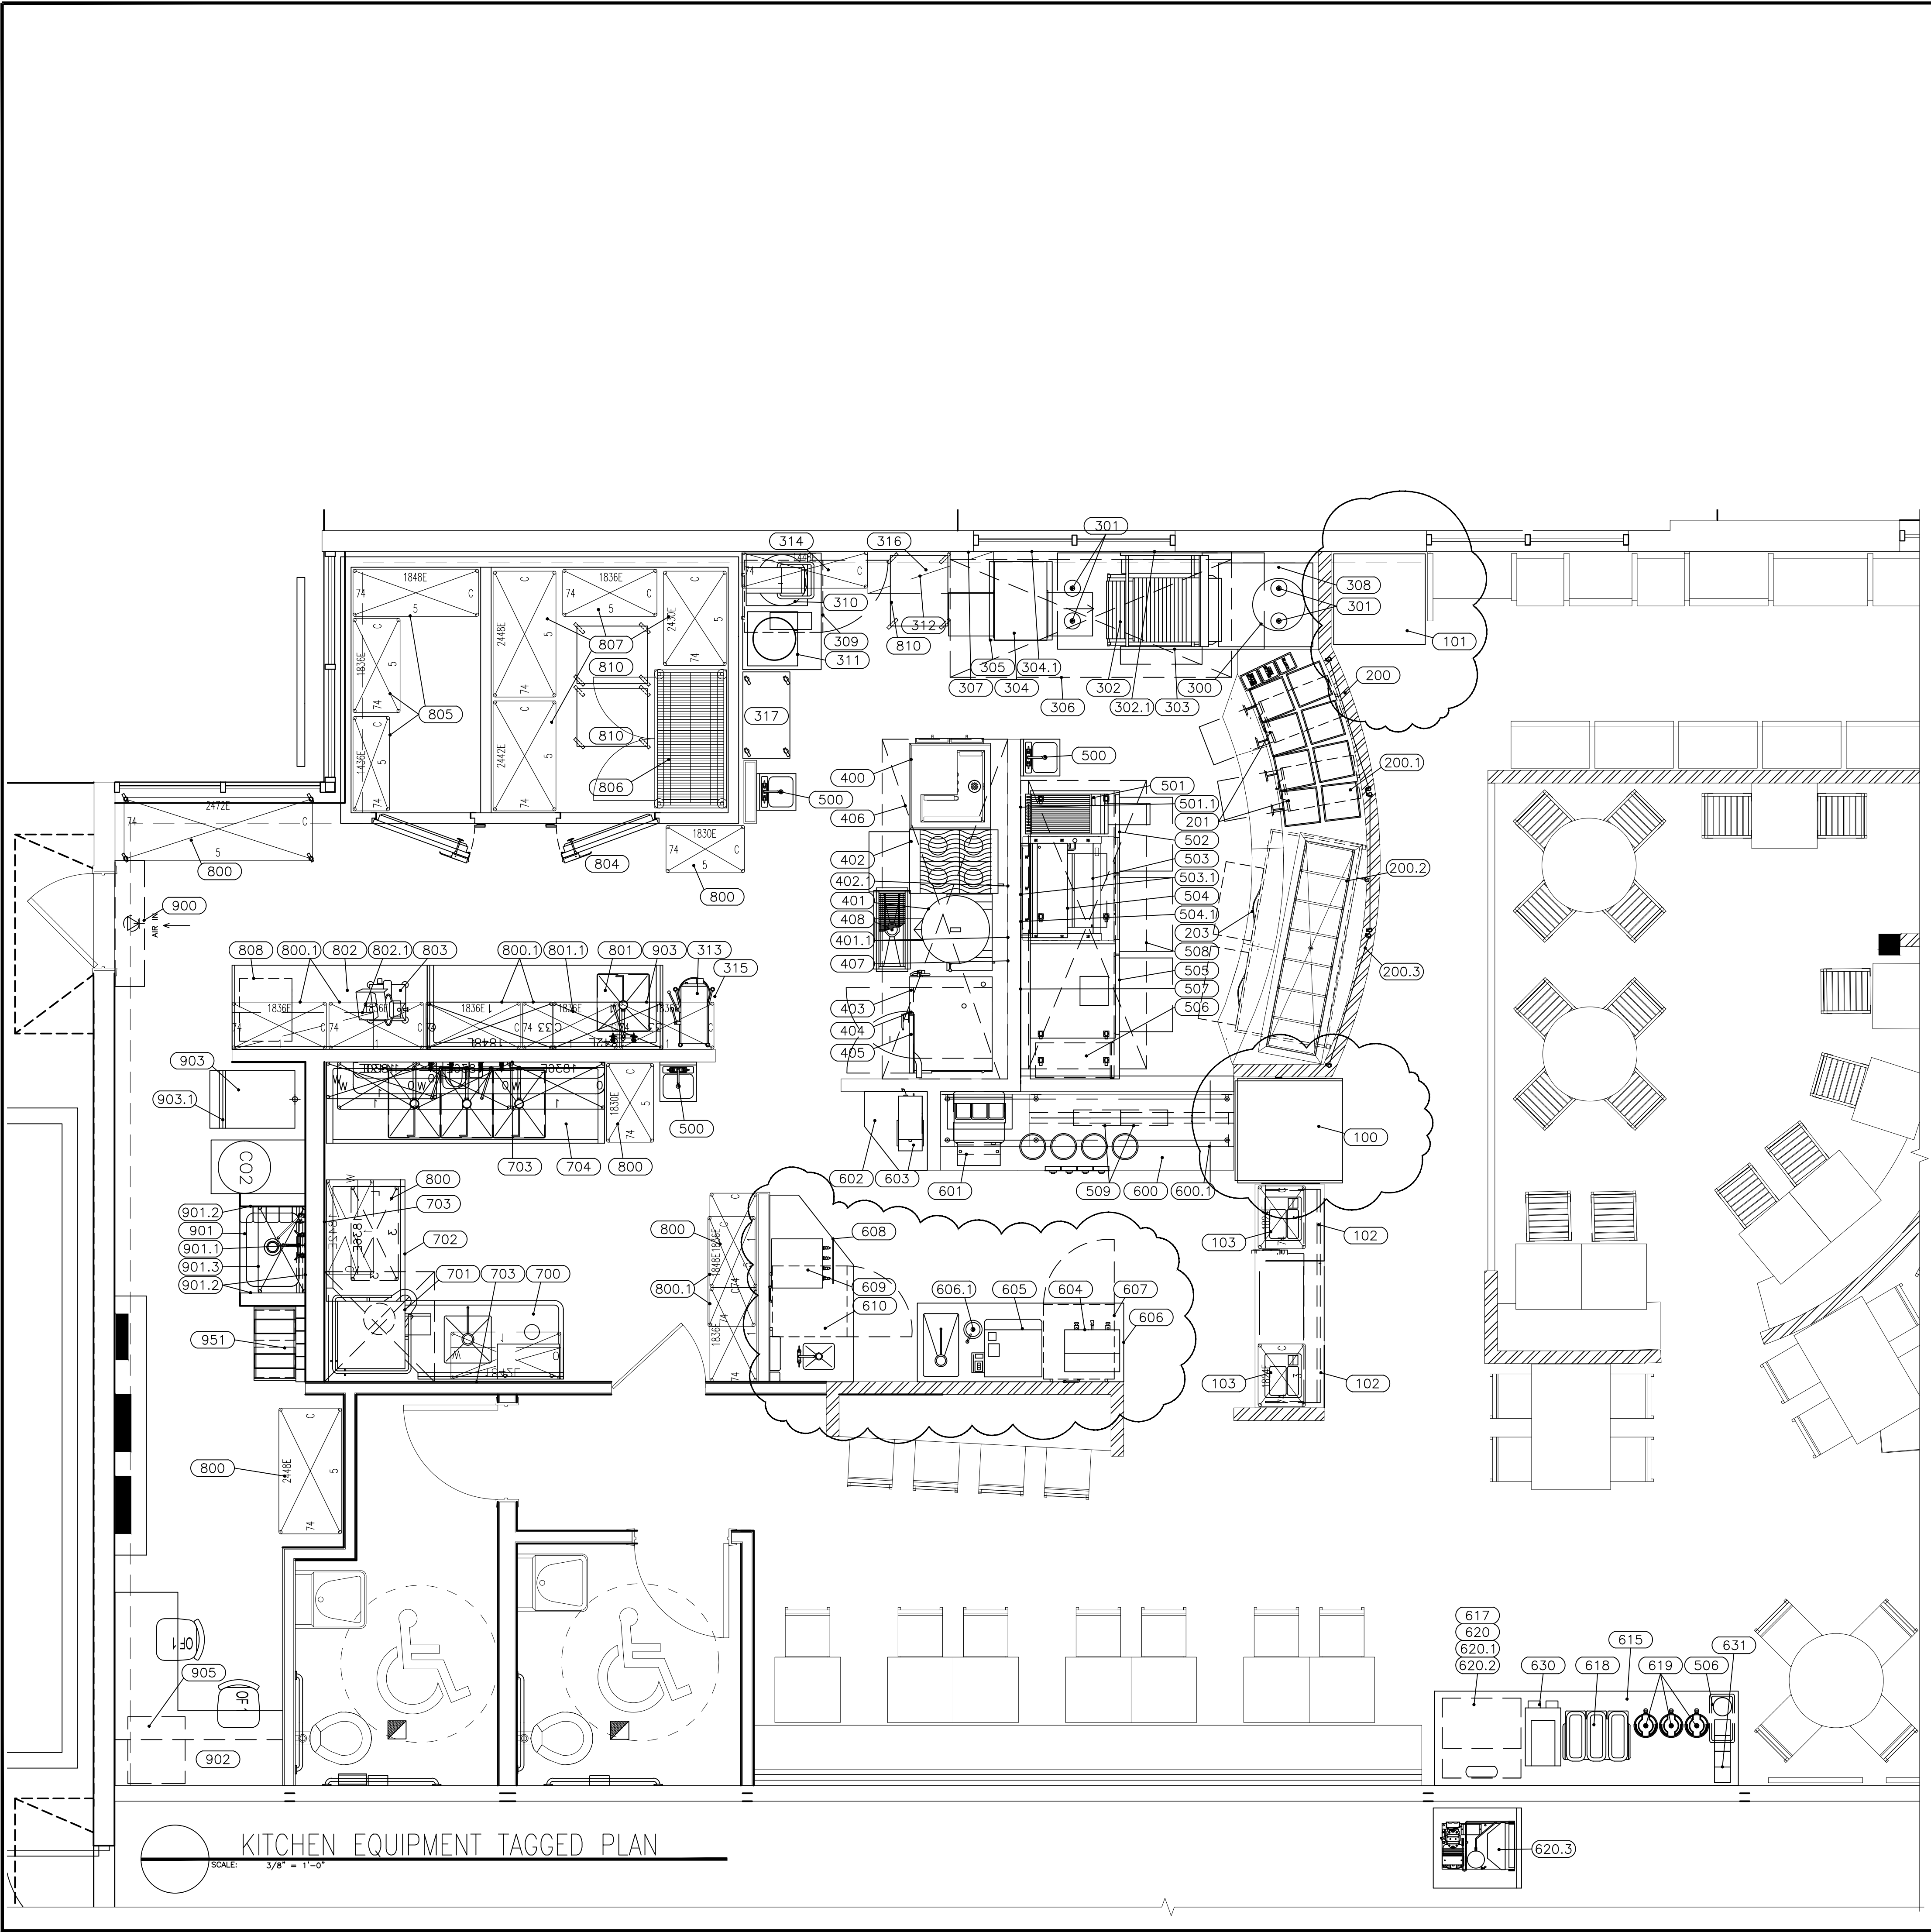

ITEM NO.	QTY	DESCRIPTION	MFR	MODEL NO.	REMARKS
100.0	1	Refrigerated Grab & Go	Structural Concepts	HOU3852R	
101.0	1	Display Case	Beverage Air	VM7-1-B	
102.0	2	Counter	NWS		
103.0	6	Wire Shelving	Olympic	J1824C	
200.0	1	Front Counter	NWS		
200.1	8	Induction Range	CookTek	B651-D	
200.2	1	Drop-in Cold Food Pan	Amtekco	ADIRSC7	
200.3	1	Sneeze-guard	NWS		
201.0	2	Warming Drawer, Free Standing	Alto-Shaam	500-2DN	
203.0	1	Low Boy, 2 section	Amtekco	AESRD1L62	
300.0	1	Heated Shelf, Free-standing	Hatco	GRSSR-20	
300.0	1	Landing Table	NWS		
301.0	4	Decorative Lamp	Hatco	DL-500-CL	
302.0	1	Broiler	Nico	JF632G	
302.1	1	Safety System Moveable Gas Connector	Dormont	1675BPQSR48	
303.0	1	Stand	NWS		
304.0	1	Conveyor Oven	Lincoln	1180-2G	
304.1	1	Safety System Moveable Gas Connector	Dormont	1675BPQSR48	
305.0	1	Stand	NWS		
306.0	1	Exhaust Hood	Captiveaire	HOOD	
307.0	1	Wall Panels	NWS	WP	
308.0	1	Worktable	NWS		
309.0	1	Reach-in Undercounter Refrigerator, 1 section	True	TUC-27	
310.0	1	Meat Tenderizer	DoughXpress	TXM-15CP	
311.0	1	Widder	La Minerva	CE-553R	
312.0	2	Ovens	Amtekco	EHS10F11648	
313.0	1	Mixer, Planetary	Varimixer	W20A	
314.0	1	Wire Shelving	Olympic	J1448K	
315.0	1	Dunnage Rack, 20"x24"	NWS	Custom	
318.0	1	Electric Oven, Conveyor	Lincoln	V2501	
317.0	1	Work Table w/Undershelf & Casters	NWS	Custom	
400.0	1	Rethermalizer, Water Tank, Electric	NWS	D967770300N	
401.0	1	Tilting Skillet, Countertop, Gas	Southbend	GCTRS-16	
401.1	1	Safety System Moveable Gas Connector	Dormont	1675BPQSR48	
402.0	1	Range, 24", 4 open burners	Southbend	4242E	
402.1	1	Safety System Moveable Gas Connector	Dormont	1675BPQSR48	
403.0	1	Combi Oven	Alto-Shaam	6-10ESU/CT	
404.0	1	Blast Chiller/Freezer	Alto-Shaam	CC3-3	
405.0	1	Worktable	NWS	WORKTABLE	
406.0	1	Exhaust Hood	Captiveaire	HOOD	
407.0	1 Lot	Stainless Steel Wall Panels	NWS	Custom	
408.0	1	Floor Trough	Advance Tabco	FTTG-1230	
500.0	3	Hand Sink	Amtekco	DHT7D	
501.0	1	Char Broiler, Gas, Heavy Duty Range, 12"	Southbend	F12N-C	
501.1	1	Safety System Moveable Gas Connector	Dormont	1675BPQSR48	
502.0	1	Refrigeration, Low Boy	NWS	D068-03-58	
503.0	1	Plancha	Southbend	F48N-TTTT	
503.1	1	Safety System Moveable Gas Connector	Dormont	1675BPQSR48	
504.0	1	Salamander	Southbend	P36-NFR	
504.1	1	Safety System Moveable Gas Connector	Dormont	1675BPQSR48	
505.0	1	Worktable	NWS	WORKTABLE	
506.0	1	Garbage Can	Rubbermaid	FG36400BRN	
507.0	1	Wall Panels	NWS	WP	
508.0	1	Hood	CaptiveAir	HOOD	
509.0	2	Overhead Warmer	Hatco	GRAH-18	
600.0	1	Expo Line w/Hot Wells & Refrigeration	NWS	Custom	
600.1	1	Overstructure for Expo Line	NWS	Custom	
601.0	1	Lettuce Crisper	Glastender	LC	
602.0	1	Worktable	NWS	WORKTABLE	
603.0	1	Tea Brewer	Curtis	TCTS10000	
604.0	1	Coffee Brewer	Fetco	CBS-2032E	
605.0	1	Espresso Cappuccino Machine	Schaerer USA	15 SO DUO PS	
606.0	1	Counter	NWS		
606.1	1	Dipperwell	Componet	K301010	Part of # 606
607.0	1	LC Refrigerator	True	TUC-27	
608.0	1	Counter, Wine w/ Sink	NWS		
609.0	1	Wine	WineKeep	WK-MON4SS	
610.0	1	Refrigerated Backbar Cabinet	True	TBB-24GAL-48GSLD	
615.0	1	Counter, Dining Room	NWS		
617.0	1	Pepsi Machine	Pepsi	250	
618.0	1	Beverage Dispenser	Grindmaster	D35-3	
619.0	1	Coffee Dispenser	Fetco	L3S-10	
620.0	1	Ice Machine	Hoshizaki	KM-500MLH	
620.1	1	Ice Machine Adapter	Hoshizaki	Adapter	
620.2	1	Ice Machine Tubing Kit	Hoshizaki	HS-0251	
620.3	1	Ice Machine Remote Condenser	Hoshizaki	SRK-8H	
630.0	1	T.B.D.	CUSTOMER		
631.0	1	T.B.D.	CUSTOMER		
700.0	1	Sinks, Soiled	NWS	F224350100N	
701.0	1	Dishwasher, Door Type	CMA Dishmachines	CMA-180TS	
702.0	1	Clean Dish	NWS	SINKS	
703.0	1	Wall Panels	NWS	WP	
704.0	1	DISHROOM, 3 Comp Sink	NWS	SINK	
800.0	5	Wire Shelving	Olympic	J1848K	
800.0	10	Wire Shelving	Olympic	J1839K	
800.0	5	Wire Shelving	Olympic	J2472K	
800.0	5	Wire Shelving	Olympic	J1436K	
800.1	1 Lot	High Wall Shelving	Olympic	Various	
801.0	1	Prep Table	NWS	F296960100N	
801.1	2	Shelves S/S	NWS	F211620100N	
802.0	1	Worktable	NWS	TABLE	
802.1	2	Shelves S/S	NWS	F211620100N	
803.0	1	Slicer	Globe	G12	
804.0	1	Prep/Refrigeration	Kopak	WV	
805.0	5	Wire Shelving	Olympic	J1848K	
805.0	5	Wire Shelving	Olympic	J1836K	
805.0	5	Wire Shelving	Olympic	J1436K	
806.0	1	Security Unit	Metro	SEC55EK3	
807.0	12	Wire Shelving	Olympic	J2442K	
807.0	6	Wire Shelving	Olympic	J1836K	
807.0	6	Wire Shelving	Olympic	J2430K	
810.0	3	Bun Pan Rack	New Age	6331	
808.0	1	Vacuum Packaging Machine	Berkel	350	
900.0	1	Air Curtain	Mars Air Systems	STD248-1UA-TS	
901.0	1	Mop Sink	Advance Tabco	9-OP-28	
901.1	1	Service Faucet	T&S Brass	B-0665-POL	
901.2	1	Wall Panels	NWS	F361210100N	
901.3	1	Wire Shelving	Olympic	J1848K	
902.0	1	Office Desk	NWS	TBD	
903.0	1	Ice Machine	Hoshizaki	KM-515MAH	
903.1	1	Ice Machine bin	Hoshizaki	B300SF	
905.0	1	Safe	Rolland	BSS3025D	
951.0	1	Bag-in-box			


KITCHEN EQUIPMENT TAGGED PLAN
SCALE: 3/8" = 1'-0"

FOR REFERENCE ONLY
CAUTION: THESE DRAWINGS ARE FOR REFERENCE ONLY. FINAL RESPONSIBILITY FOR PLUMBING, ELECTRICAL & VENTILATION EQUIPMENT SHALL REMAIN WITH THE CLIENT. THESE DRAWINGS ARE NOT TO BE USED AS A BASIS FOR CONSTRUCTION. THESE DRAWINGS ARE NOT INTENDED TO BE, NOR SHOULD THEY BE, USED AS WORKING DRAWINGS. FOR ALL MECHANICAL REQUIREMENTS, REFER TO THE APPROVED ARCHITECTURAL DRAWINGS. WATERSTROM ASSUMES NO LIABILITY IN PROVIDING THESE DRAWINGS.

AMAIZE
amaize

THIS DRAWING IS THE PROPERTY OF N. WASSERSTROM & SONS, INC. AND IS TO REMAIN IN THE POSSESSION OF OUR REPRESENTATIVE. UNLESS PERMISSION IS GIVEN BY N. WASSERSTROM & SONS, INC. AND MUST BE RETURNED WHEN REQUESTED.

KITCHEN EQUIPMENT PLUMBING PLAN AND SCHEDULE
DATE: 01/29/2014
SCALE: 3/8" = 1'-0"
DRAWN: MJH
DWG. NUMBER: 12120600
SHEET: K-201
1 OF 7 SHEETS

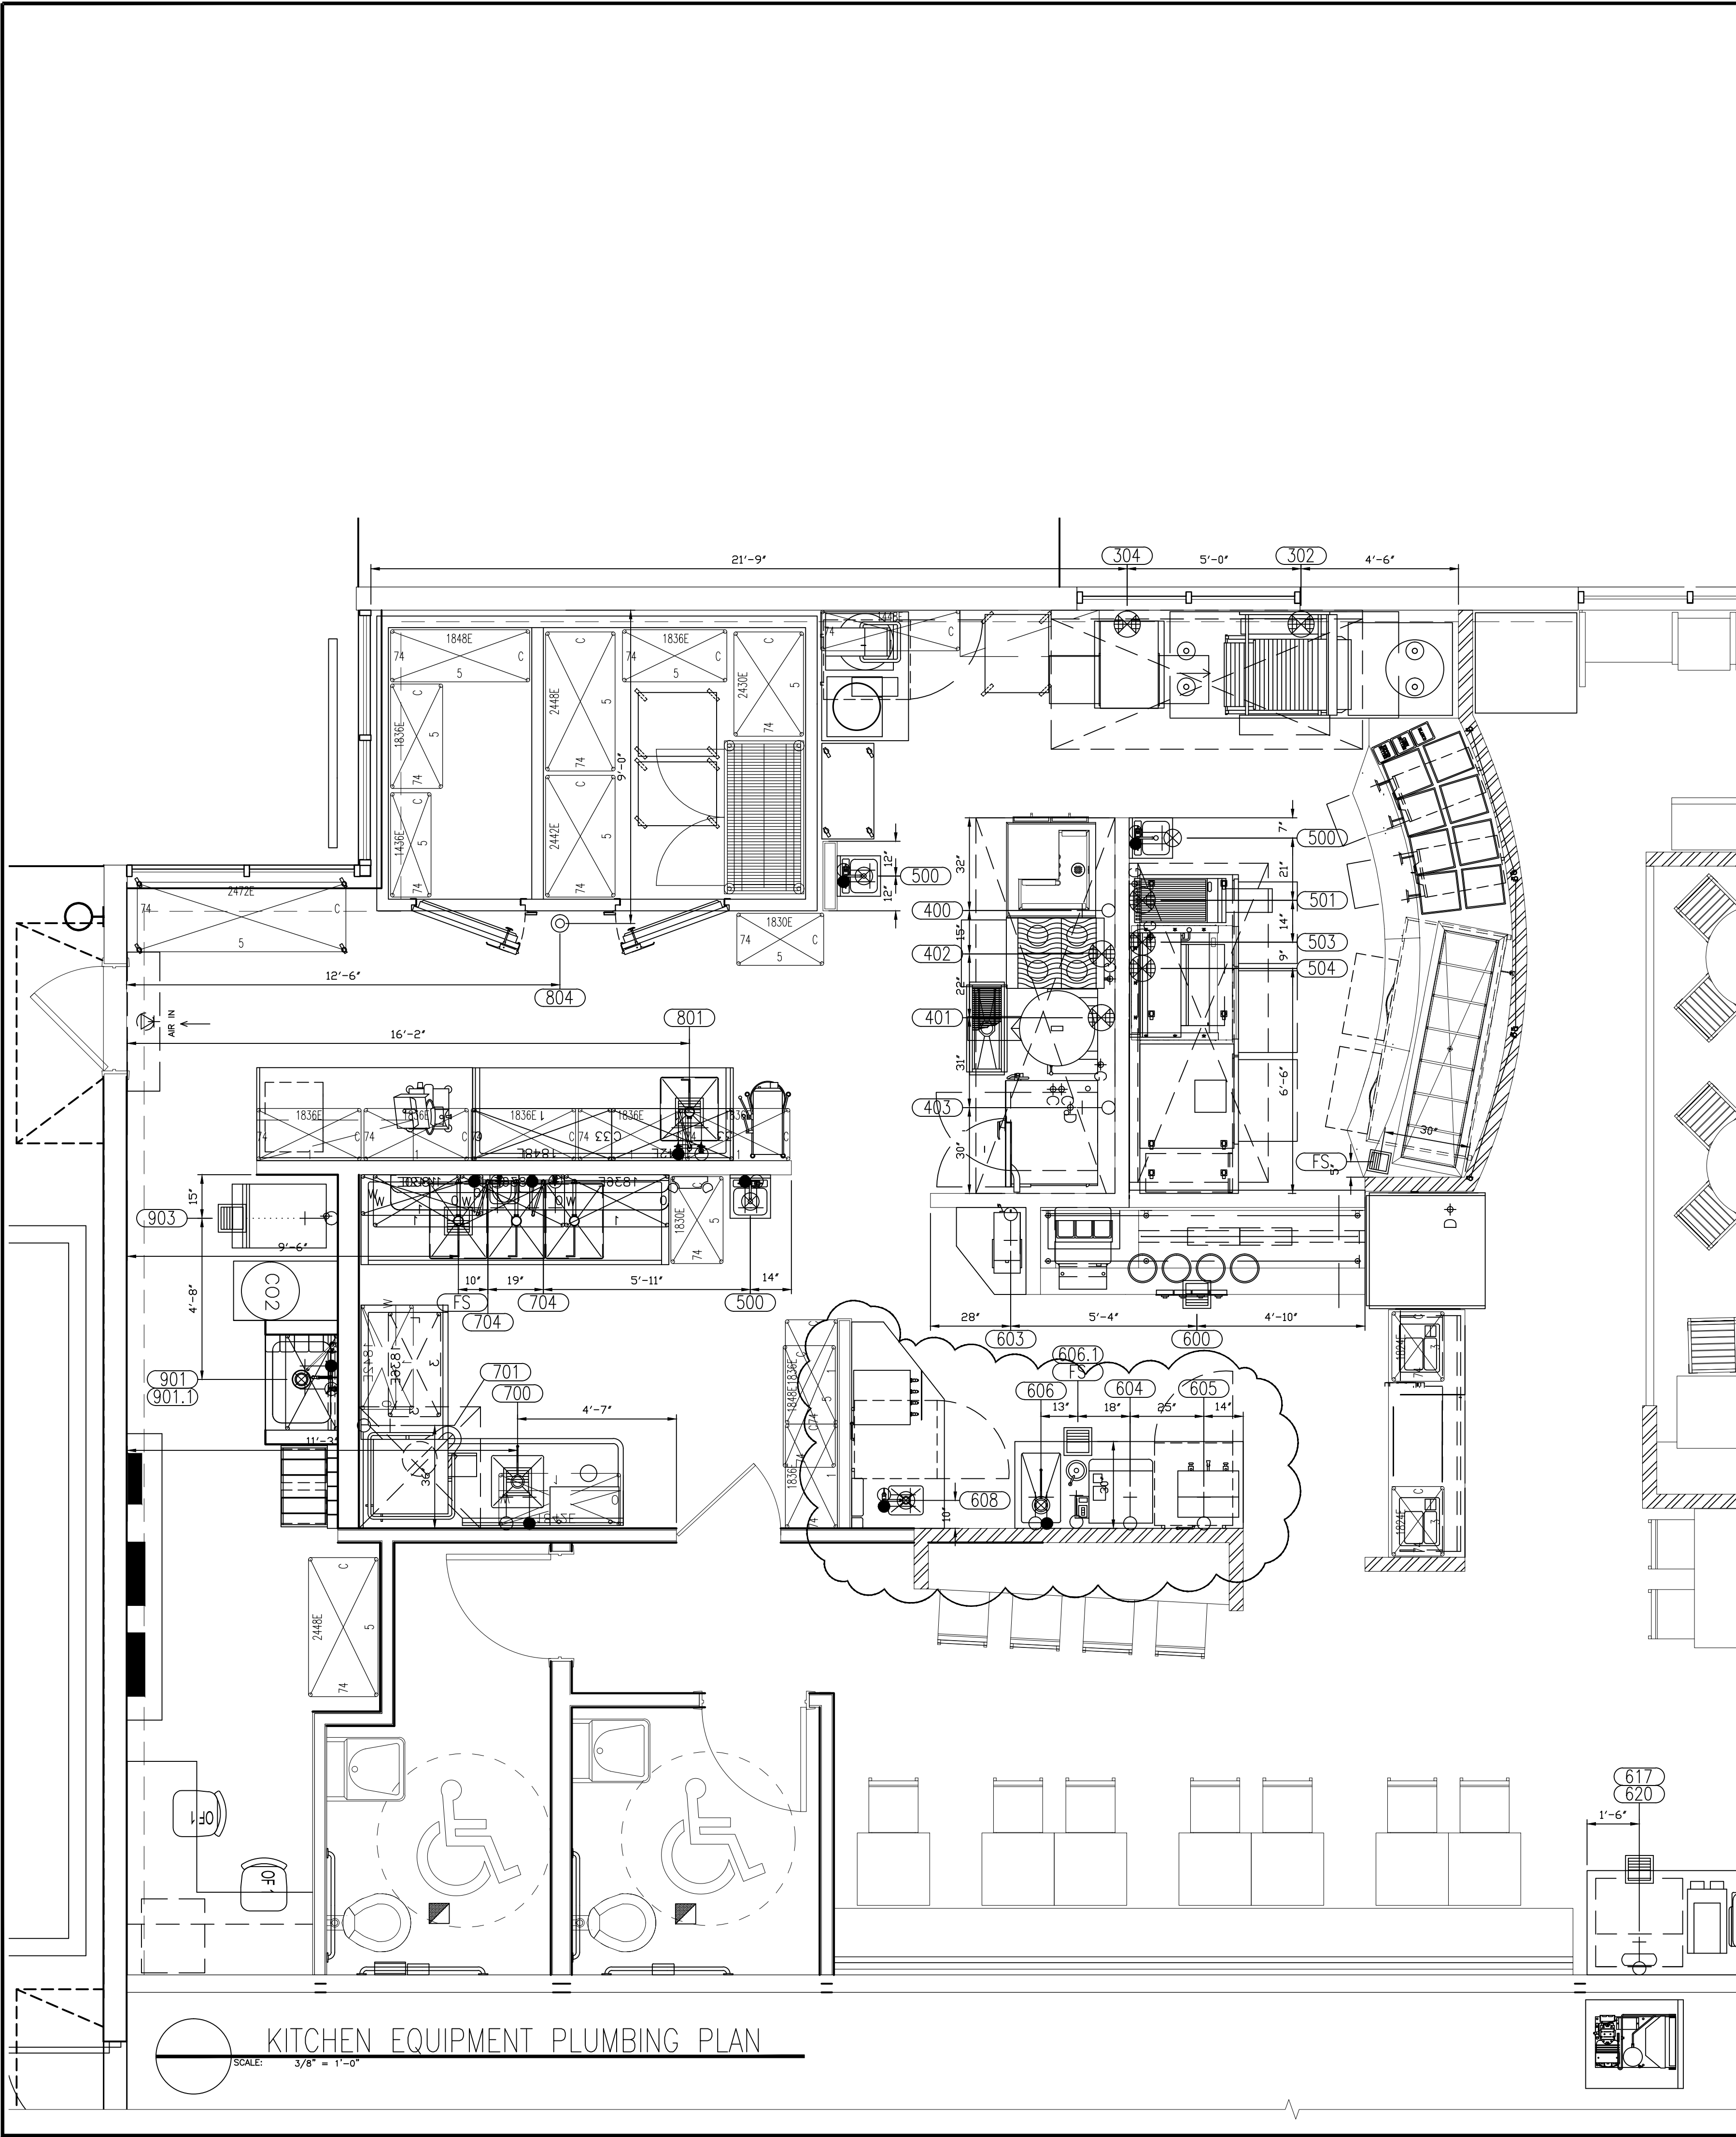

PLUMBING LEGEND

- COLD WATER (C.W.)
- HOT WATER (H.W.)
- ⊕ DIRECT CLOSED WASTE
- ⊗ FLOOR DRAIN WITH GRATE
- ⊕ FLOOR DRAIN WITH FUNNEL
- ⊙ OPEN SITE DRAIN (O.S.) (HUB DRAIN)
- ⊗ FLOOR SINK
- ▤ TRENCH DRAIN WITH GRATE
- ▤ GAS SUPPLY BRANCH DROP
- ⊗ GAS SUPPLY (INDIVIDUAL)
- REFRIGERATION LINE SYMBOL
- INSTALL PER MFG. INSTRUCTIONS

A.F.F. - ABOVE FINISHED FLOOR
D.F.C. - DROP FROM CEILING
B.T.C. - BRANCH TO CONNECTION
V.W.O. - VERIFY WITH OWNER

THIS DIMENSIONAL ROUGH-IN INDICATES ONLY THE SERVICES REQUIRED FOR EQUIPMENT FURNISHED BY THE WASSERSTROM COMPANY.


ADDITIONAL ROUGH-IN EQUIPMENT FURNISHED BY OTHERS HAS BEEN SHOWN FOR CONVENIENCE PURPOSE ONLY. THESE REQUIREMENTS SHOULD BE VERIFIED WITH THE OWNER.

PLUMBING SCHEDULE																
ITEM NO.	QTY	DESCRIPTION	MFR	MODEL NO.	CW (in)	CW AFF (in)	HW (in)	HW AFF (in)	IW	DW	DW AFF	GAS (in)	GAS AFF	MBTU	REMARKS	ITEM NO.
200.2	1	Drop-In Gold Food Pan	Amtekco	ADIRSC7							1/2"				TO FS	200.2
302.0	1	Boiler	Nisco	JF832G								3/4"	36"	37.0		302.0
304.0	1	Conveyor Oven	Lincoln	1180-2G								(2) 3/4"	36"	(2) 40.0		304.0
400.0	1	Rethermalizer, Water Tank, Electric	NWS	D967770300N			1/2"	18"		2"					TO FS	400.0
401.0	1	Tiling Skillet, Countertop, Gas	Southbend	GCTRS-16								3/4"	29"	30.0		401.0
402.0	1	Range, 24", 4 open burners	Southbend	H424ZE								3/4"	30"	153.0		402.0
403.0	1	Combi Oven	Alto-Shaam	6-10ESUCT	(2) 3/4"	6"				1-1/2"						403.0
500.0	3	Hand Sink	Amtekco	DH17D	3/8"	18"	3/8"	18"		1-1/2"						500.0
501.0	1	Char Broiler, Gas, Heavy Duty Range, 12"	Southbend	P12N-C								1-1/4"	12"	32.0		501.0
503.0	1	Plancha	Southbend	P48N-TTT								3/4"	36"	120		503.0
504.0	1	Salamander	Southbend	P36-NFR								3/4"	60"	40.0		504.0
600.0	1	Expo Line W/Soup Wells	NWS						3"						DRAIN TO FS	600.0
603.0	1	Tea Brewer	Curtis	TCTS10000	1/4"											603.0
604.0	1	Coffee Brewer	Fetco	CBS-52H-15	3/8"											604.0
605.0	1	Espresso Cappuccino Machine	Schaerer USA	TS SO DUO FS	3/8"				1"							605.0
606.0	1	Coffee Counter W/Dipperwell	NWS		3/8"	18"				1"						606.0
606.1	1	Dipperwell	Componet	K301010	1/4"										Part of # 606	606.1
608.0	1	Wine Counter W/Handsink	NWS		3/8"	18"	3/8"	18"		1-1/2"						608.0
617.0	1	PEPS MACHINE	Vendor	250											By Vendor	617.0
620.0	1	ICE MACHINE	HOSHIZAKI	KM-830MLH											By Vendor	620.0
700.0	1	Solled Dish Sink W/Pre-Rinse Sprayer	NWS	F224350100N	3/8"	18"	3/8"	18"							TO FS	700.0
701.0	1	Dishwasher, Door Type	CMA Dishmachines	CMA-180TS			3/4"	18"	2"						TO FS	701.0
704.0	1	3-BOWL SINK W/Pre-Rinse Sprayer	NWS	SINK	3/8"	18"	3/8"	18"							TO FS	704.0
801.0	1	Prep Table W/Integral Dumpsink	NWS	F206960100N	3/8"	18"	3/8"	18"							TO FS	801.0
804.0	1	WALK-IN COOLER/FREEZER	Vollrath	40861					3"							804.0
901.0	1	Mop Sink	Advance Tabco	9-OP-28						2"						901.0
901.1	1	Service Faucet	T&S Brass	B-0665-POL	1/2"	36"	1/2"	36"								901.1
903.0	1	ICE MACHINE	HOSHIZAKI	KM-515MAH					1"						TO FS	903.0

KITCHEN EQUIPMENT PLUMBING PLAN
SCALE: 3/8" = 1'-0"

FOR REFERENCE ONLY
CAUTION: THESE DRAWINGS ARE FOR REFERENCE ONLY. FINAL RESPONSIBILITY FOR PLUMBING, ELECTRICAL & MECHANICAL EQUIPMENT SHALL BE THE RESPONSIBILITY OF THE CONTRACTOR. THESE DRAWINGS ARE NOT TO BE USED AS A BASIS FOR CONSTRUCTION. THESE DRAWINGS ARE NOT TO BE USED AS A BASIS FOR CONSTRUCTION. THESE DRAWINGS ARE NOT TO BE USED AS A BASIS FOR CONSTRUCTION. THESE DRAWINGS ARE NOT TO BE USED AS A BASIS FOR CONSTRUCTION.

AMAIZE
amaize

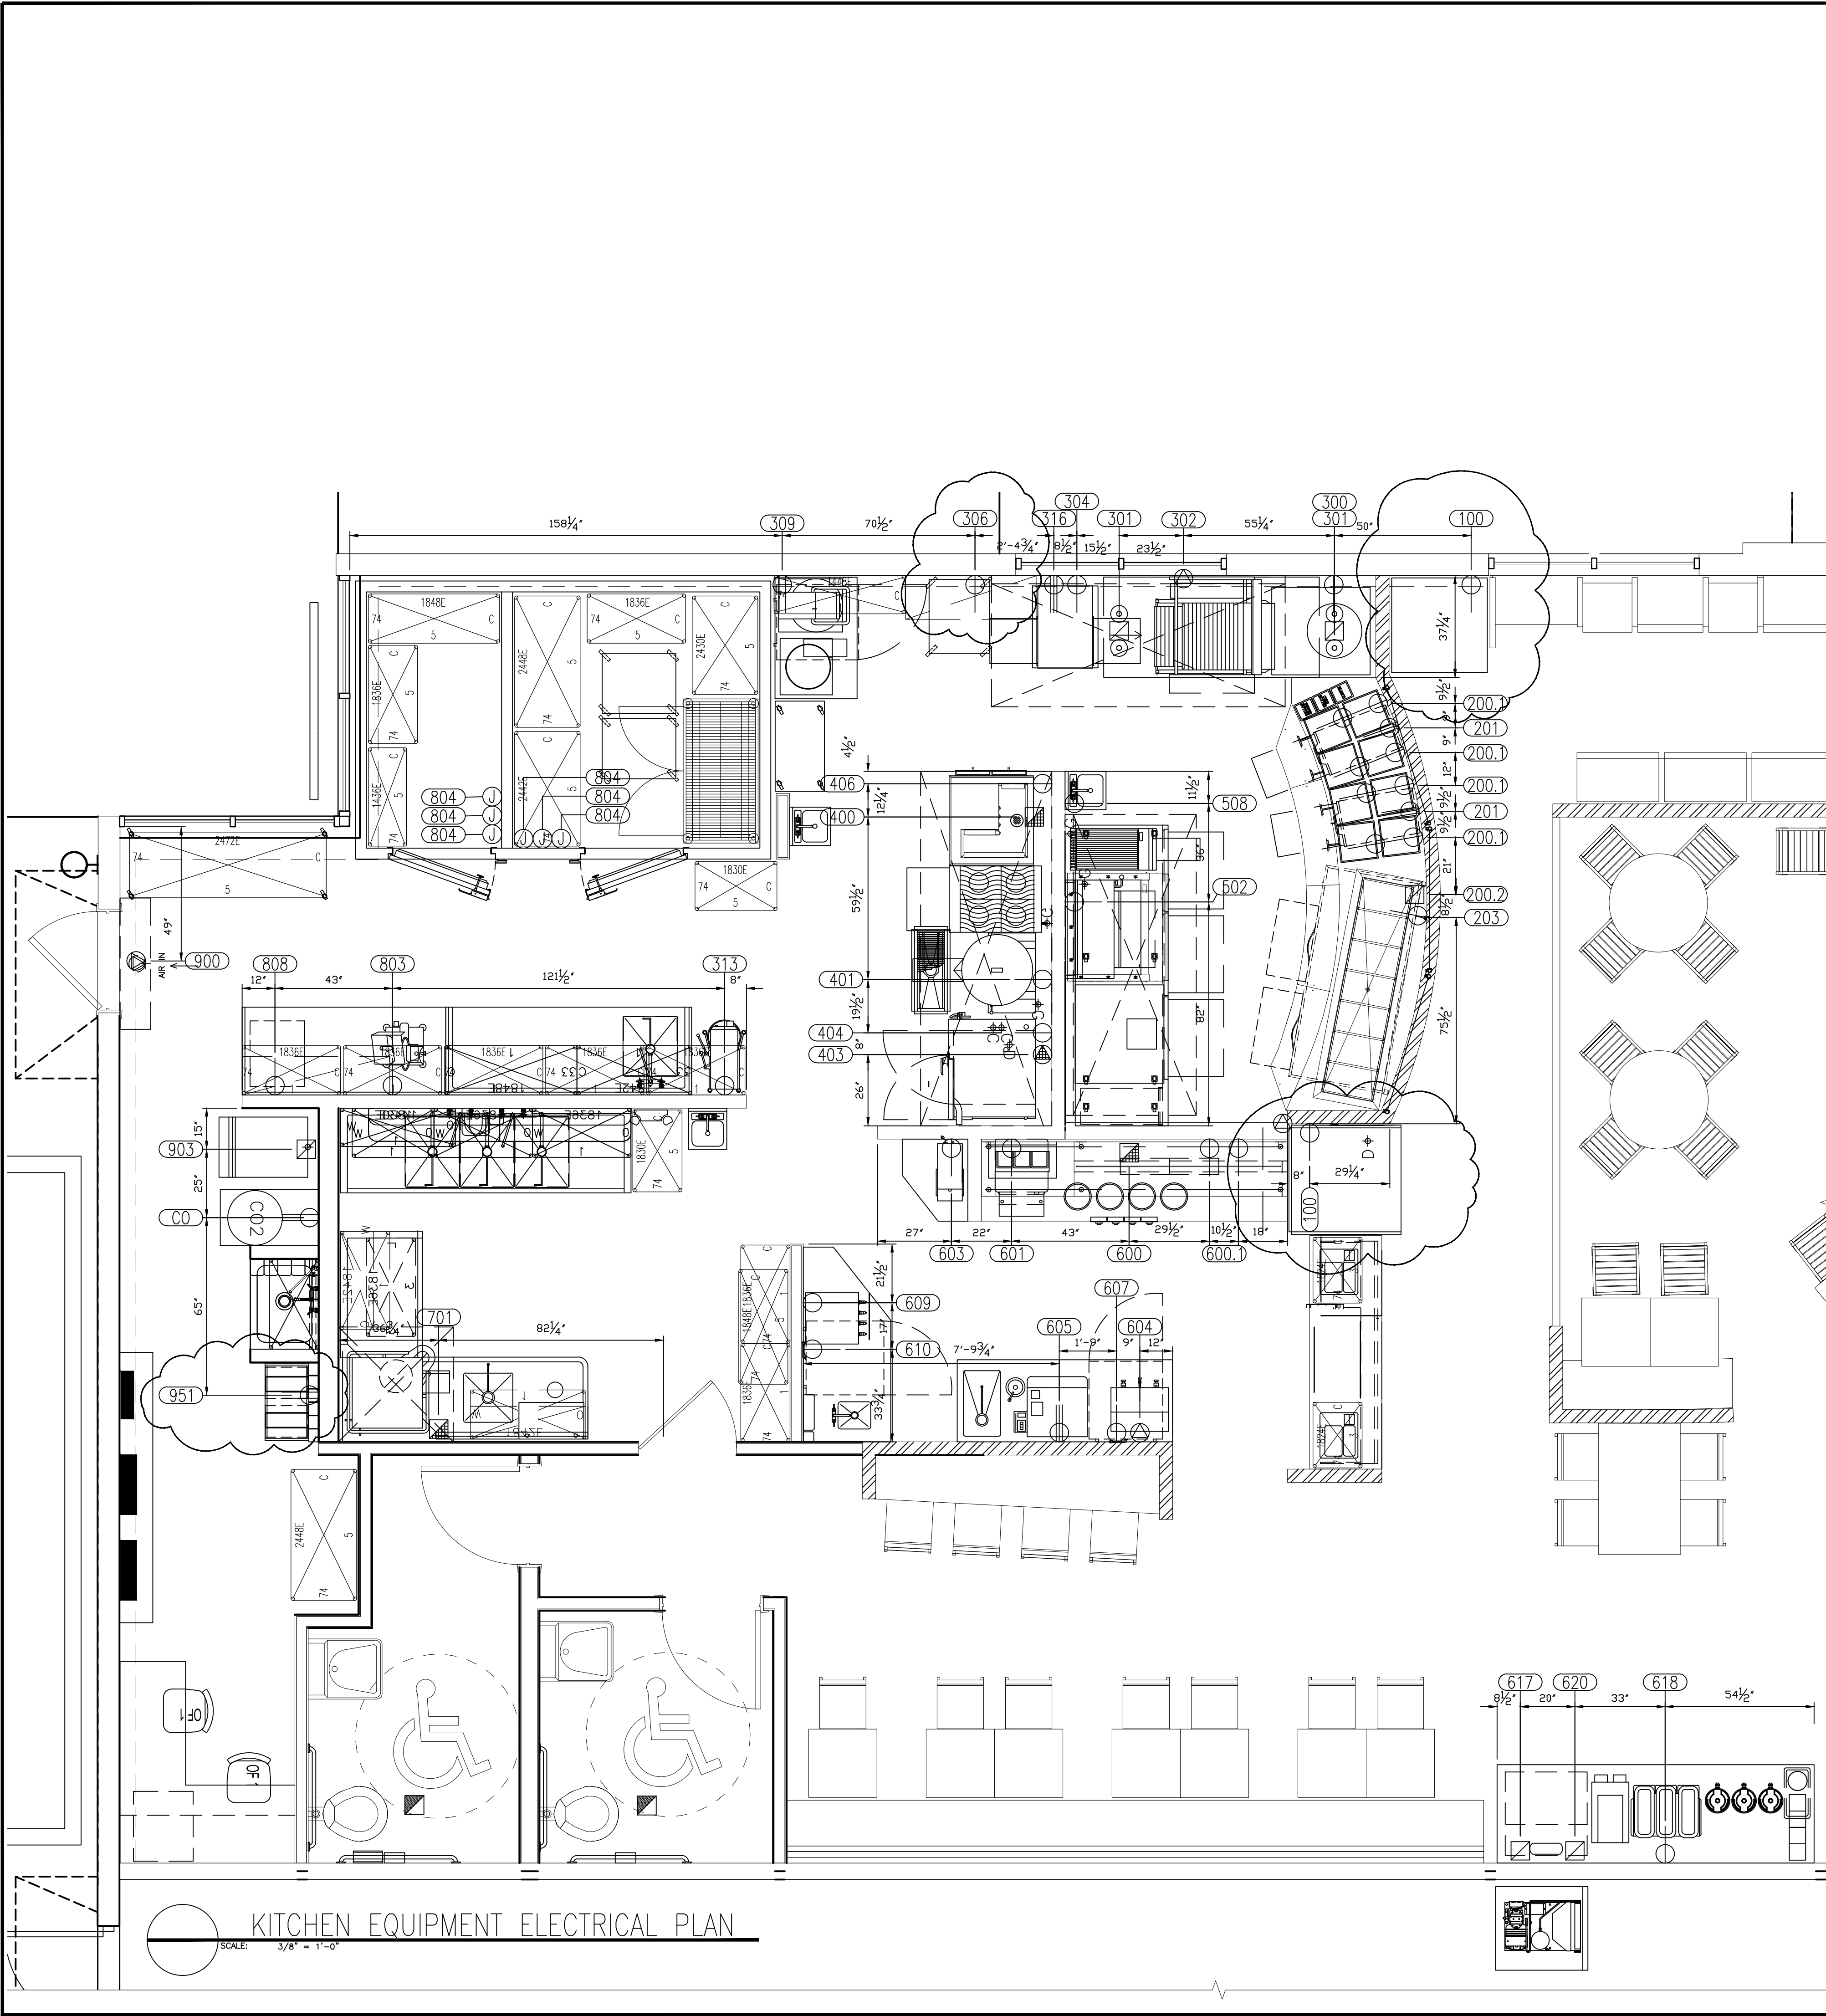

ELECTRICAL LEGEND


- 120V, 1PH SINGLE RECEPTACLE
 - ⊕ 120V, 1PH DUPLEX RECEPTACLE
 - 120V, 1PH DIRECT CONNECTION
 - ⊠ 120V, 1PH JUNCTION BOX
 - ⊕ 208-240V, 1PH SINGLE RECEPTACLE
 - ⊕ 208-240V, 1PH DIRECT CONNECTION
 - ⊠ 208-240V, 1PH JUNCTION BOX
 - ⊕ 208-240V, 3PH SINGLE RECEPTACLE
 - ⊕ 208-240V, 3PH DIRECT CONNECTION
 - ⊠ 208-240V, 3PH JUNCTION BOX
 - EXHAUST FAN
 - ⊕ SUPPLY AIR FAN
- C.O. - CONVENIENCE OUTLET
A.F.F. - ABOVE FINISHED FLOOR
D.F.C. - DROP FROM CEILING
B.T.C. - BRANCH TO CONNECTION
V.W.O. - VERIFY WITH OWNER
M.I.C. - MOUNT IN COUNTER

THIS DIMENSIONAL ROUGH-IN INDICATES ONLY THE SERVICES REQUIRED FOR EQUIPMENT FURNISHED BY THE WASSERSTROM COMPANY.
ADDITIONAL ROUGH-IN EQUIPMENT FURNISHED BY OTHERS HAS BEEN SHOWN FOR CONVENIENCE PURPOSE ONLY. THESE REQUIREMENTS SHOULD BE VERIFIED WITH THE OWNER.


ELECTRICAL SCHEDULE

ITEM NO.	QTY	DESCRIPTION	MFR	MODEL NO.	AMPS	KW	HP	VOLTS	CYCLE	PHASE	NEMA	AFF	Remarks	ITEM NO.
100.0	1	Refrigerated Grab & Go	Structural Concepts	HOU3852R	12.0			115	60	1	5-15P	39"		100.0
101.0	1	Display Case	VM71-B		3.0			115	60	1	5-15P	12"		101.0
200.1	8	Deluxon Preper	Coop	85SLD	5.5	.65		100/120	60	1	5-15P	12"		200.1
200.2	1	Drop-In Cold Food Pan	Amtekco	ADIRSC7	4.5			115	60	1	12"			200.2
201.0	2	Warming Drawer, Free Standing	Alto-Shaam	800-2DN	5.3	.64		120	60	1	5-15P	12"	5' cord	201.0
203.0	1	Reach-in Undercounter Refrigerator, 2 section	Amtekco	AESRD1L62	5.0		1/5	115	60	1	5-15P	12"		203.0
300.0	1	Heated Shelf, Free-standing	Halco	GRSSR-20	3.3	.4		120	60	1	5-15P	48"		300.0
301.0	4	Decorative Lamp	Halco	DL-500-CL	2.08	.25		120	60	1	12"		JB IN CLG	301.0
302.0	1	Broiler	Nieco	JF632G	5.0			115	60	1	5-15P	36"		302.0
304.0	1	Conveyor Oven	Lincoln	1180-2G	(2) 7.0	(2) 10.0		(2) 120	60	1	(2) 5-15P	48"		304.0
306.0	1	Hood	CaptiveAir	HOOD	5.0			120	60	1			SEE SPECS	306.0
309.0	1	Reach-in Undercounter Refrigerator, 1 section	True	TUC-27	3.9		1/6	115	60	1	5-15P	12"		309.0
313.0	1	Mixer, Planetary	Vannmixer	V250A	12		1	115	60	1	5-15P	12"		313.0
316.0	1	Electric Oven, Conveyor	Lincoln	V2501	27.0	6.0		208	60	1	6-50P	54"		316.0
400.0	1	Rethermalizer, Water Tank, Electric	NWS	D96770300N	37.5	9.0		240	60	1	DIRECT	12"		400.0
401.0	1	Tilting Skillet, Countertop, Gas	Southbend	GCTRS-16	2.0			120	60	1	5-15P	22"	cord & plug	401.0
403.0	1	Combi Oven	Alto-Shaam	8-10ESVCT	27	12.0		208-240	60	3	48"		403.0	
404.0	1	Blast Chiller/Freezer	Alto-Shaam	QC2-3	16	1.84	1/2	115	60	1	5-20P	12"		404.0
406.0	1	Exhaust Hood	Captiveaire	HOOD	5.0			120	60	1			SEE SPECS	406.0
502.0	1	Refrigeration	NWS	D669-03-58	10.0			120	60	1	5-15P	12"		502.0
508.0	1	Hood	CaptiveAir	HOOD	5.0			120	60	1			SEE SPECS	508.0
600.0	1	Refrigeration	NWS	TBD	7.5	.863	1/3	115	60	1	5-15P	12"		600.0
600.0	1	Expo Line	NWS		24.0			208	60	1	DIRECT	28"		600.0
600.1	1	Overstructure for Expo Line	Halco	GRAH-18	3.0			120	60	1	Direct	28"		600.1
601.0	1	Lettuce Crisper	Glastender	LC	5.3	.6	1/4	120	60	1		92.5"	Undershelf	601.0
603.0	1	Tea Brewer	Curtis	TCTS10000	13.8	1.65		120	60	1	5-15P	48"		603.0
604.0	1	Coffee Brewer	Fetco	CBS-52H-15	22.4	4.6		120/208	60	1	Direct	28"		604.0
605.0	1	Espresso Cappuccino Machine	Scherer USA	15 SO DUO PS	30	9		208	60	1	L6-30P	28"		605.0
607.0	1	Refrigerator, Undercounter	TRUJE	TUC-27	3.9			115	60	1	5-15P	12"		607.0
609.0	1	Wine Dispenser	Wine Keeper	WK-MON4SS	0.8			120	60	1	5-15P	48"		609.0
610.0	1	Refrigerator, Undercounter	True	TBB-24GAL-48GSLD	7.6		1/3	115	60	1	5-15P	12"		610.0
617.0	1	PEPSI MACHINE	CUSTOM	250				120	60	1				617.0
618.0	1	Beverage Dispenser	Grindmaster	G35-3	8.5			120	60	1	5-15P	48"		618.0
620.0	1	ICE MACHINE	HOSHIZAKI	KM-830MLH	9.1			115	60	1	Direct	60"		620.0
701.0	1	Dishwasher, Door Type	CMA Dishmachines	CMA-180TS	24	8.646		208	60	3	Direct	76"		701.0
803.0	1	Slicer	Globe	G12	3		1/2	115	60	1	5-15P	48"		803.0
804.0	1	Walk-In Cooler			4.5			120	60	1	Direct		SEE SPECS	804.0
		Walk-In Freezer			13.0			120	60	1	Direct		SEE SPECS	
		Vacuum Packaging Machine	Bertal	350	14.2		1-1/4	115	60	1	5-15P	12"	8' cord & plug	808.0
900.0	1	Air Curtain	Mars Air Systems	ST1248-1UA-TS	20.0		1.0	115	60	1	Direct	106"		900.0
903.0	1	ICE MACHINE	HOSHIZAKI	KM-515MAH	9.1			115	60	1	Direct	80"		903.0
951.0	1	Bag N Box	Vendor	Custom				120	60	1			By Vendor	951.0


KITCHEN EQUIPMENT ELECTRICAL ROUGH IN PLAN AND SCHEDULE
DATE: 01/29/2014
SCALE: 3/8" = 1'-0"
DRAWN: MJH
DWG. NUMBER: 12120600
SHEET: K-301 OF (7) SHEETS

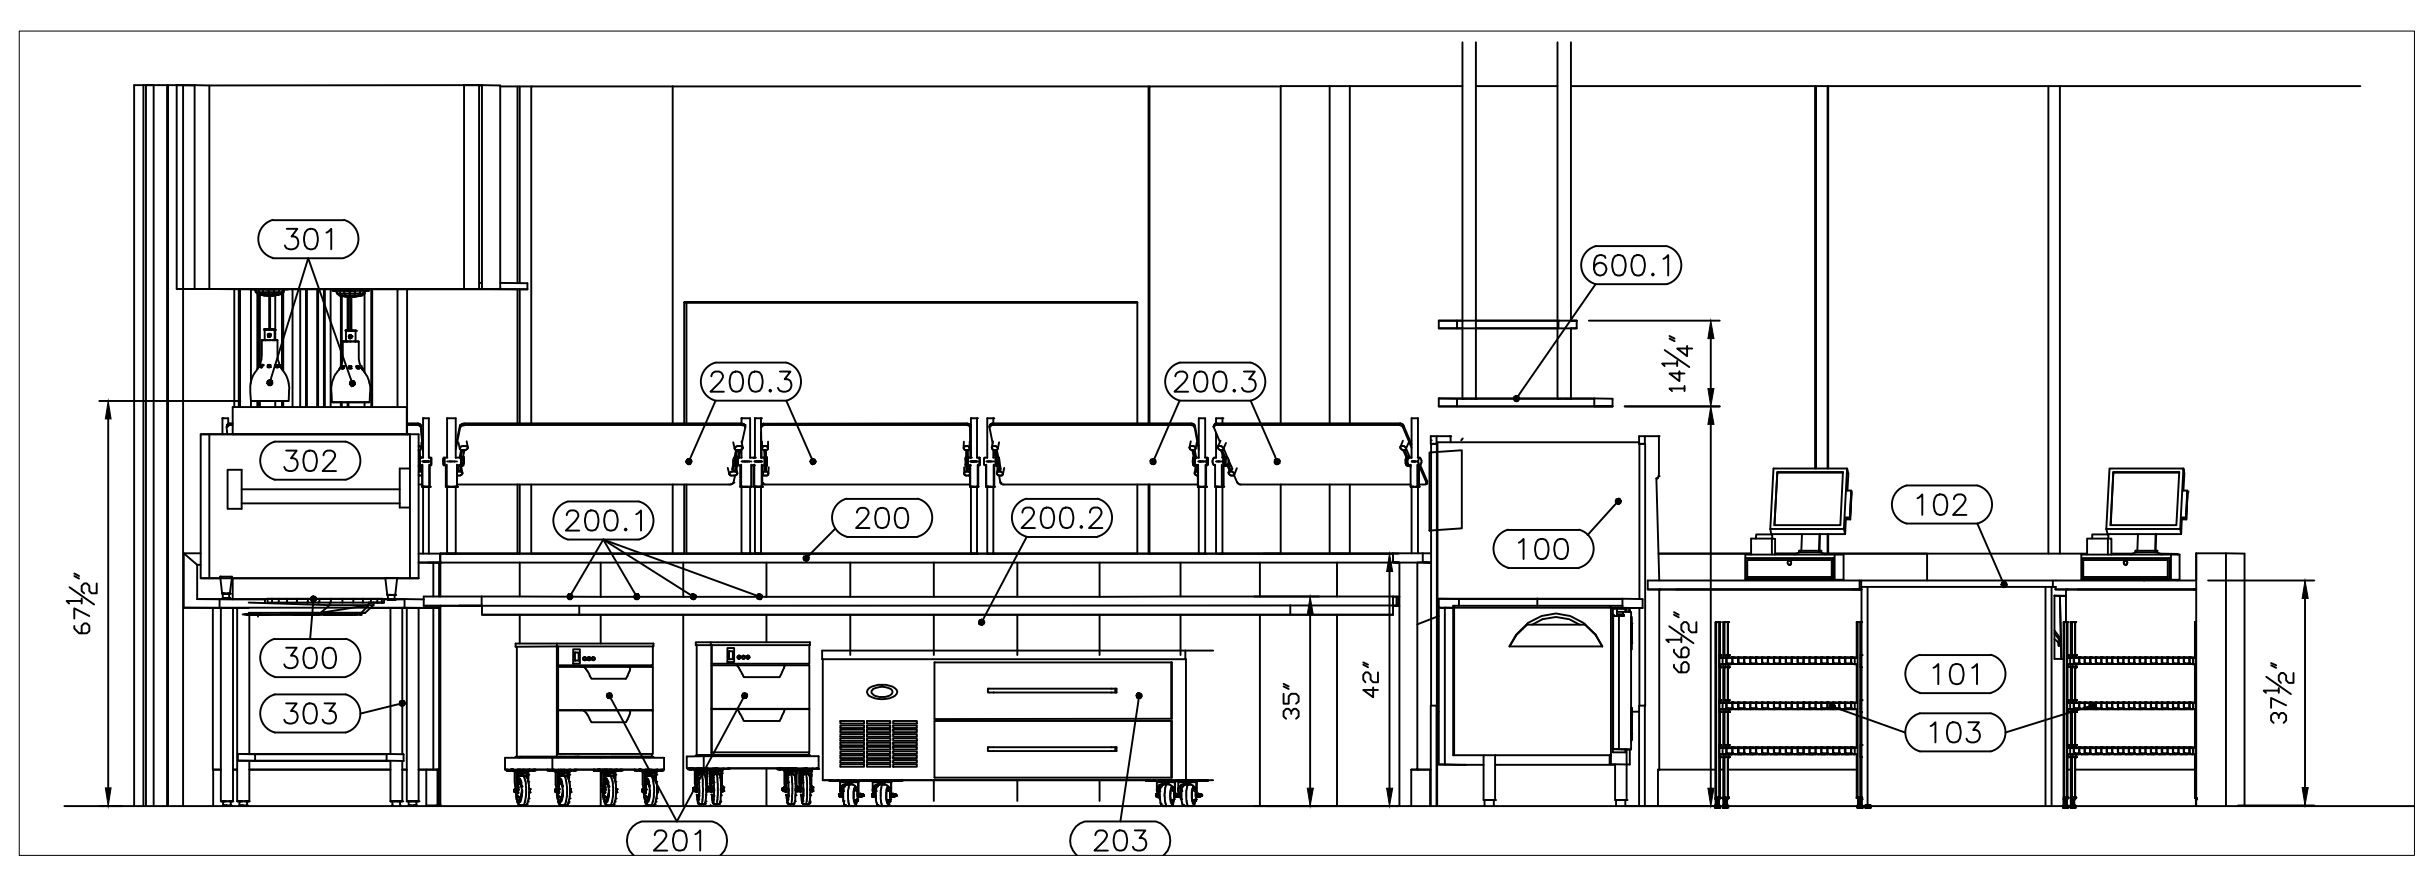


1 KITCHEN EQUIPMENT TAGGED PLAN
K-401 SCALE: 3/8" = 1'-0"

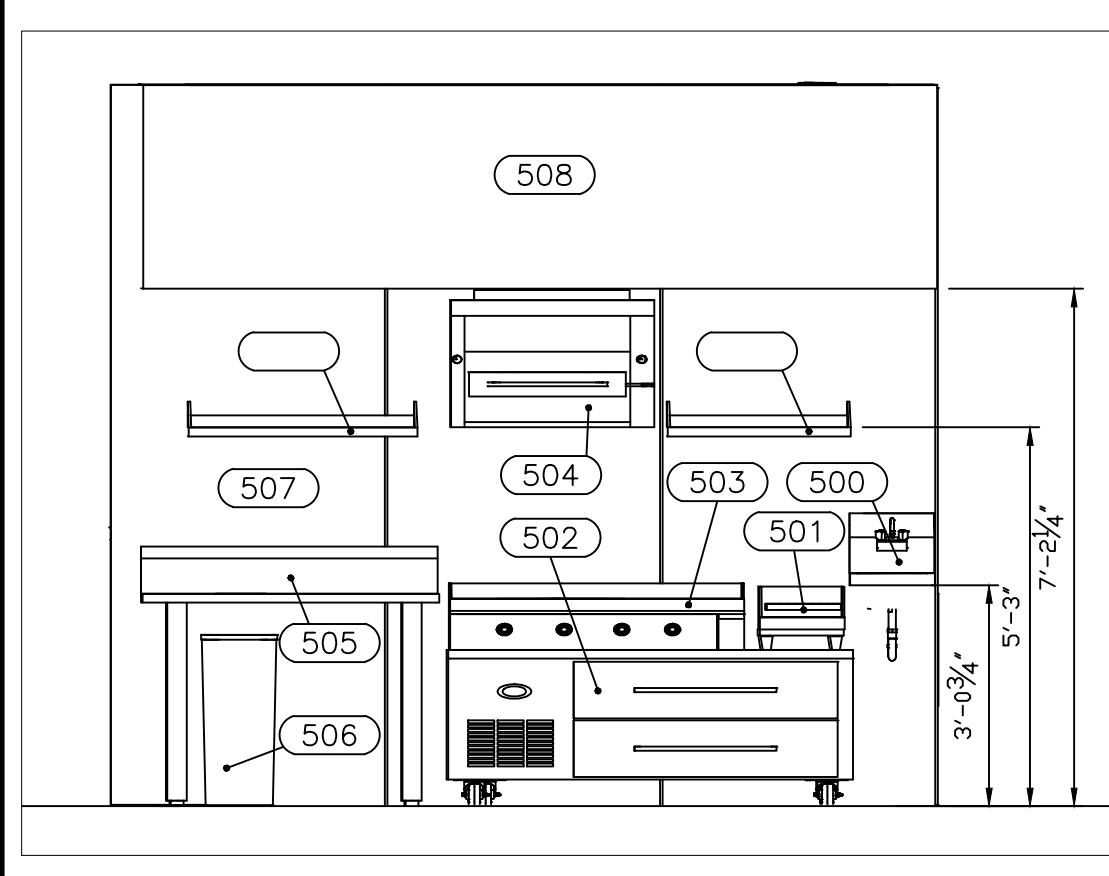


2 COOK LINE ELEVATION
K-401 SCALE: 3/8" = 1'-0"

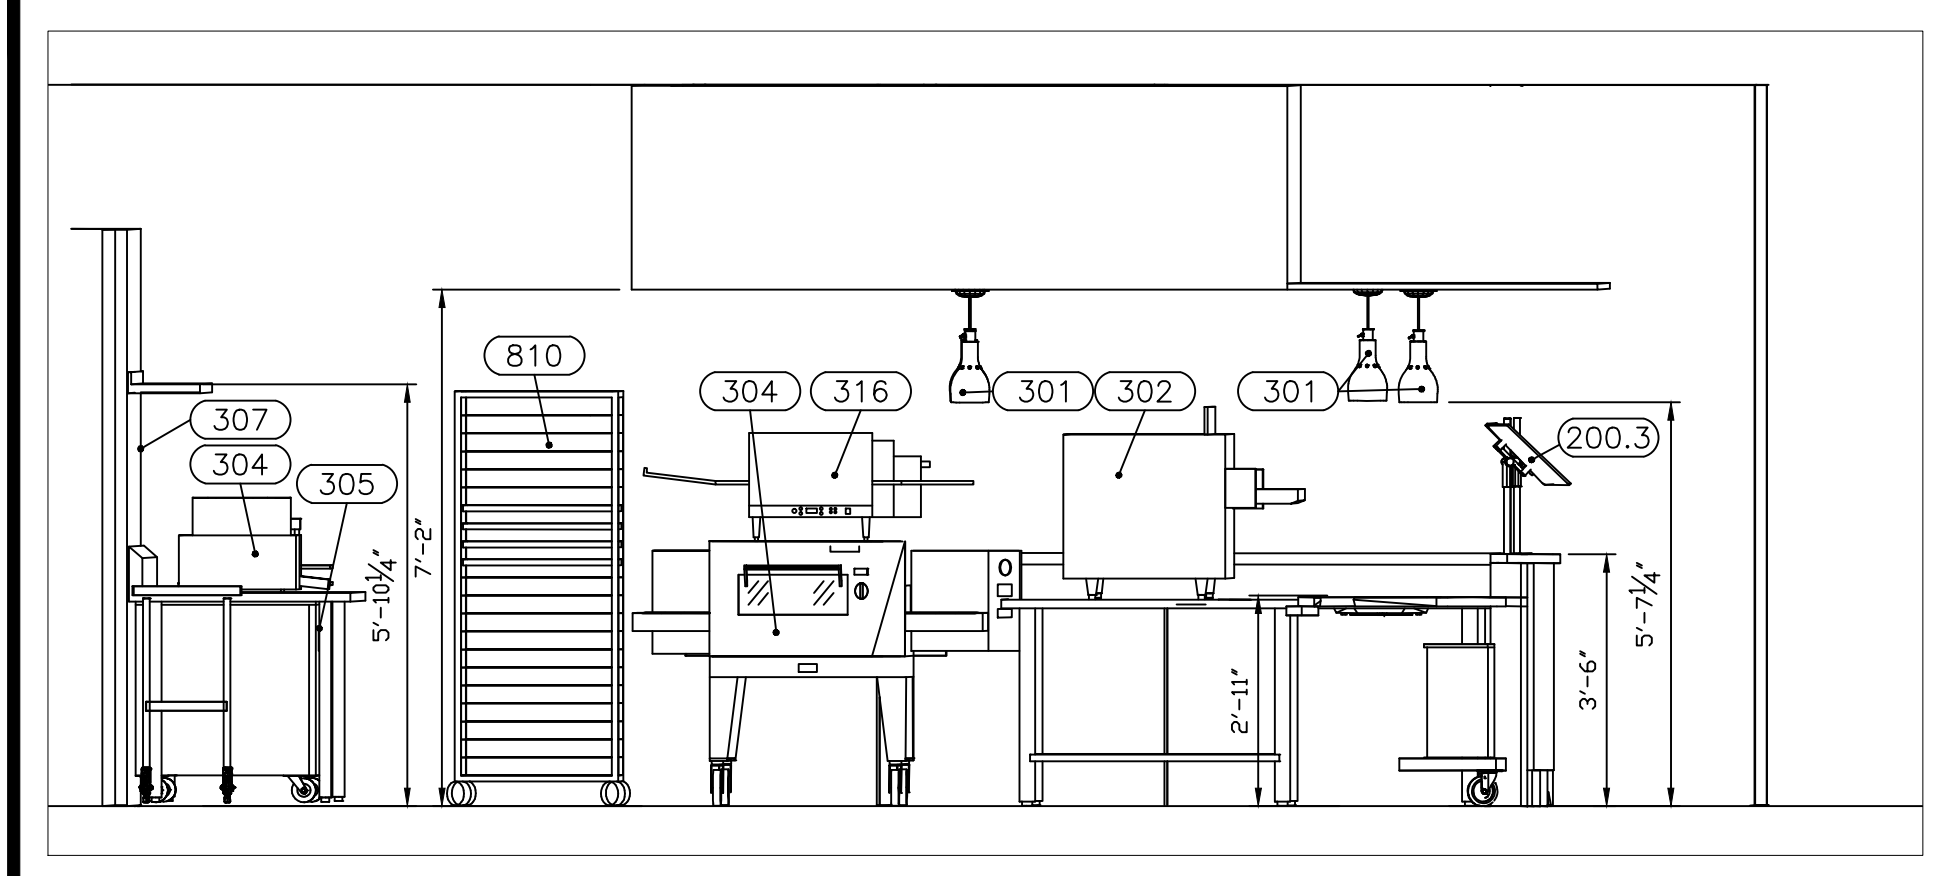


3 COOK LINE ELEVATION
K-401 SCALE: 3/8" = 1'-0"

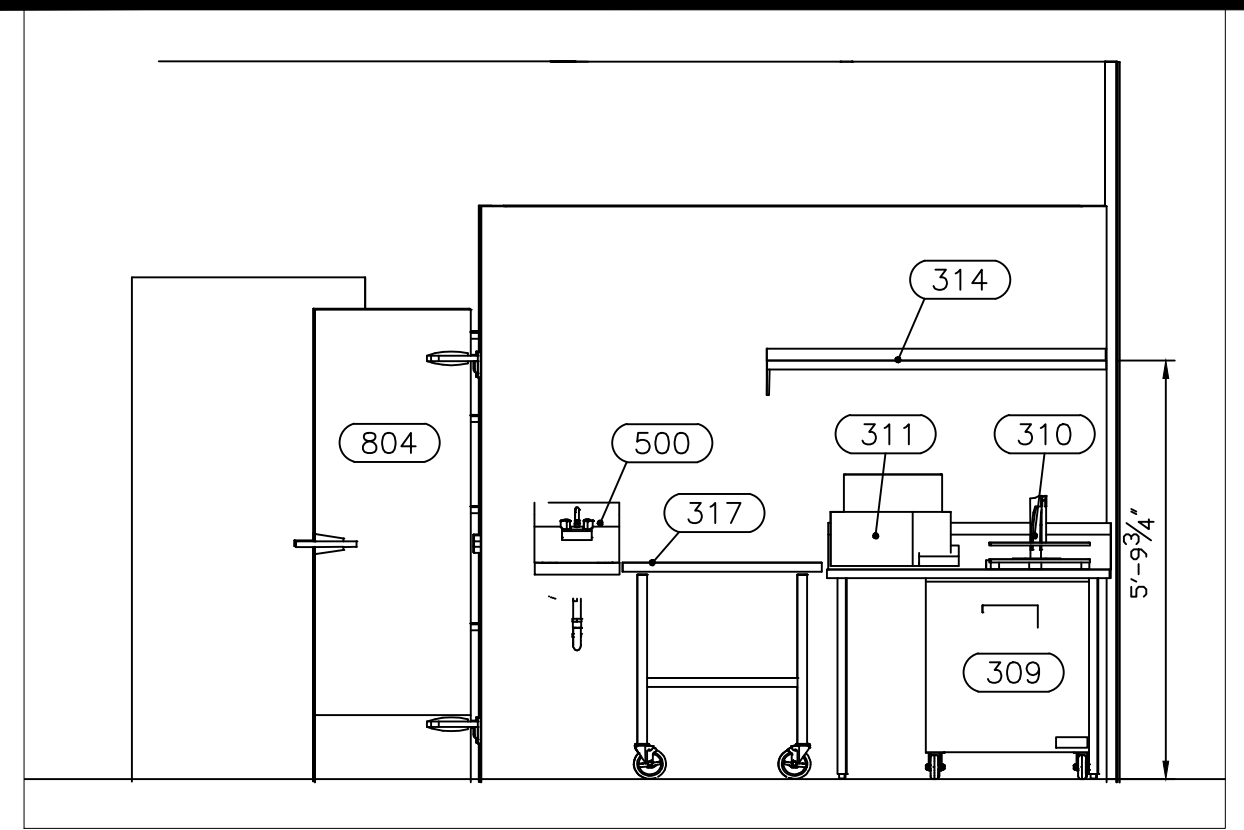


4 HAND SINK ELEVATION
K-401 SCALE: 3/8" = 1'-0"

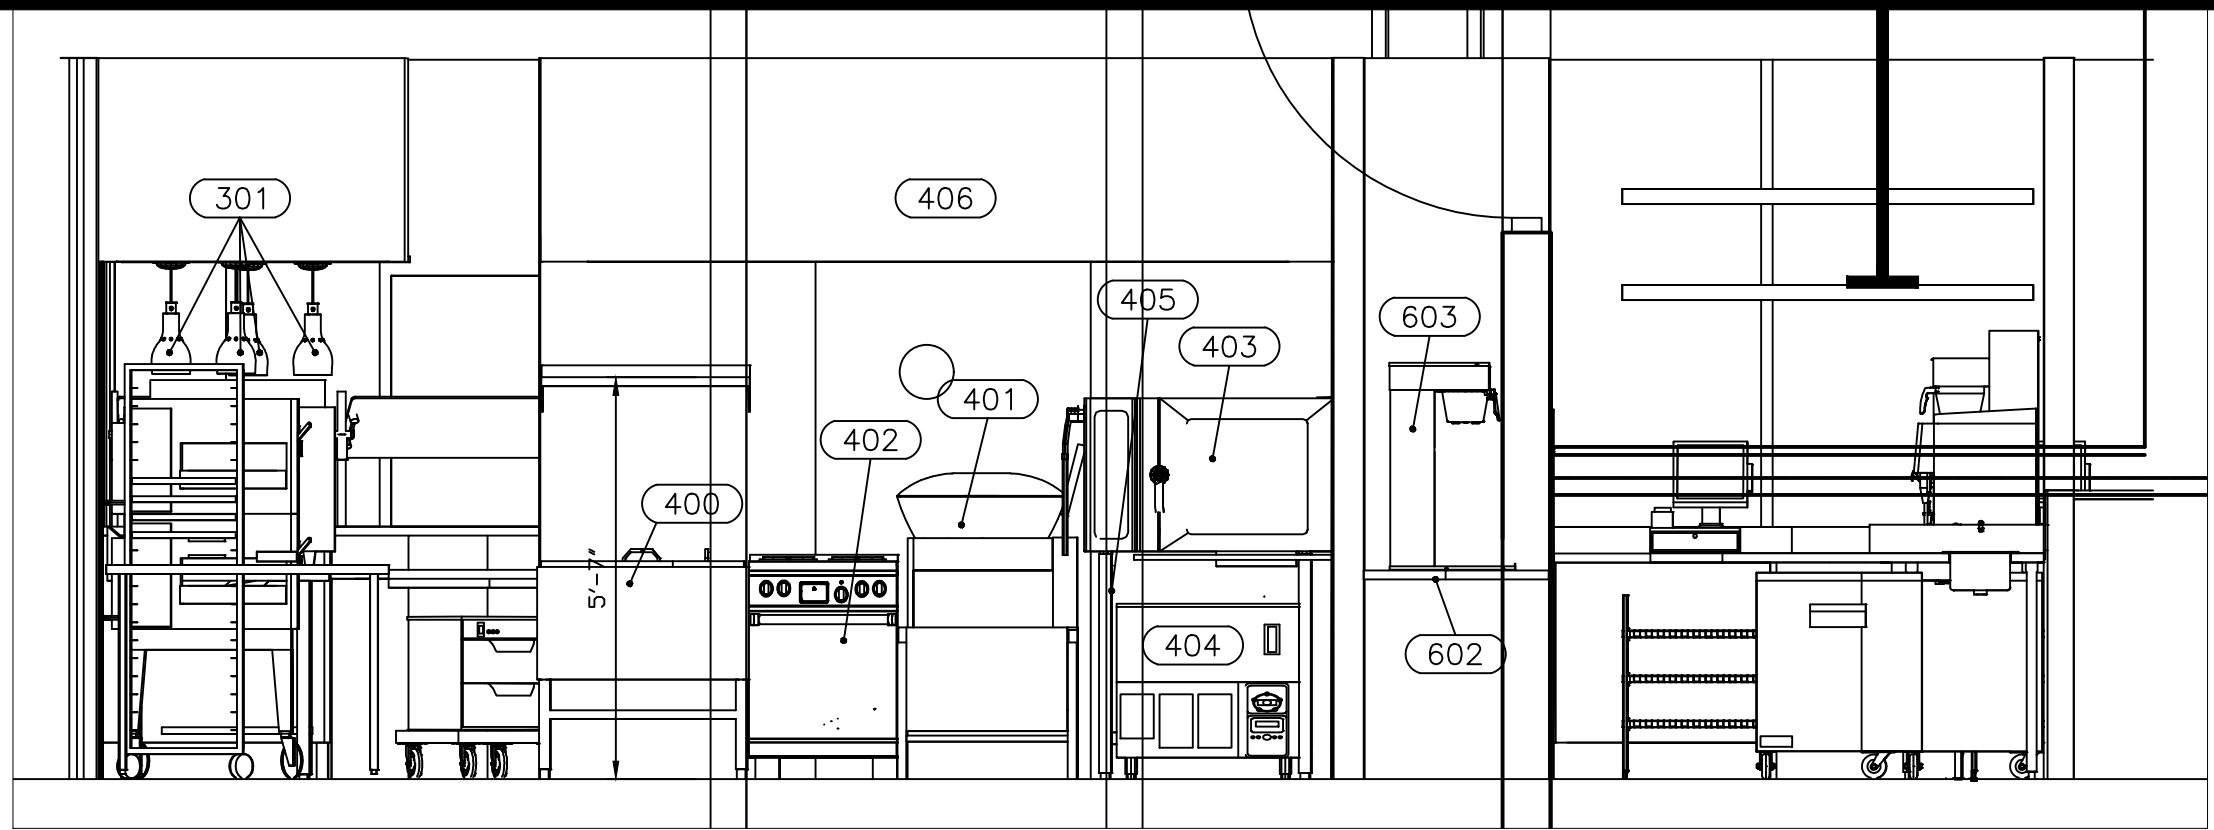


5 HAND SINK ELEVATION
K-401 SCALE: 3/8" = 1'-0"

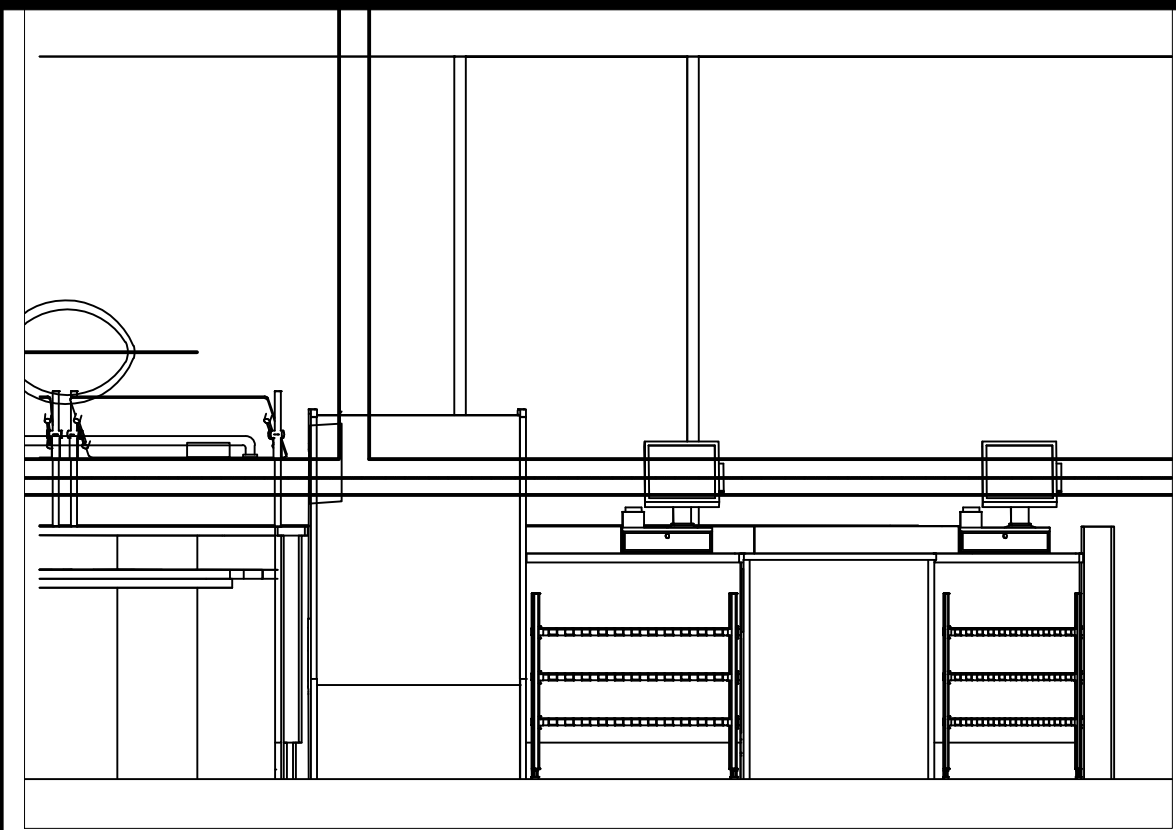


6 CASHIER ELEVATION
K-401 SCALE: 3/8" = 1'-0"

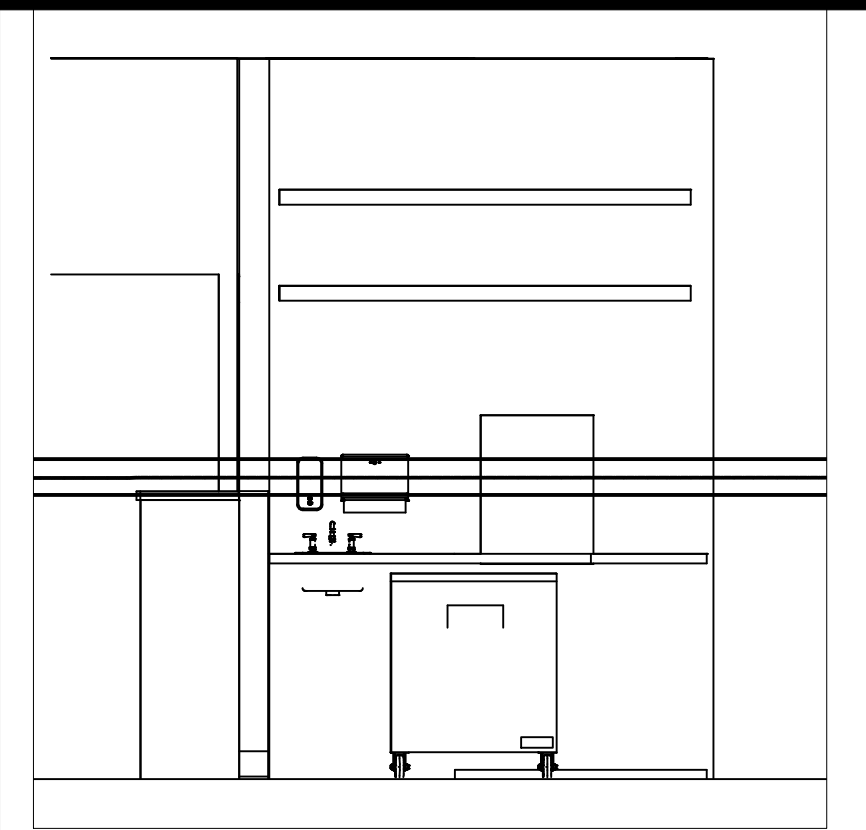


7 EXPO LINE ELEVATION
K-401 SCALE: 3/8" = 1'-0"

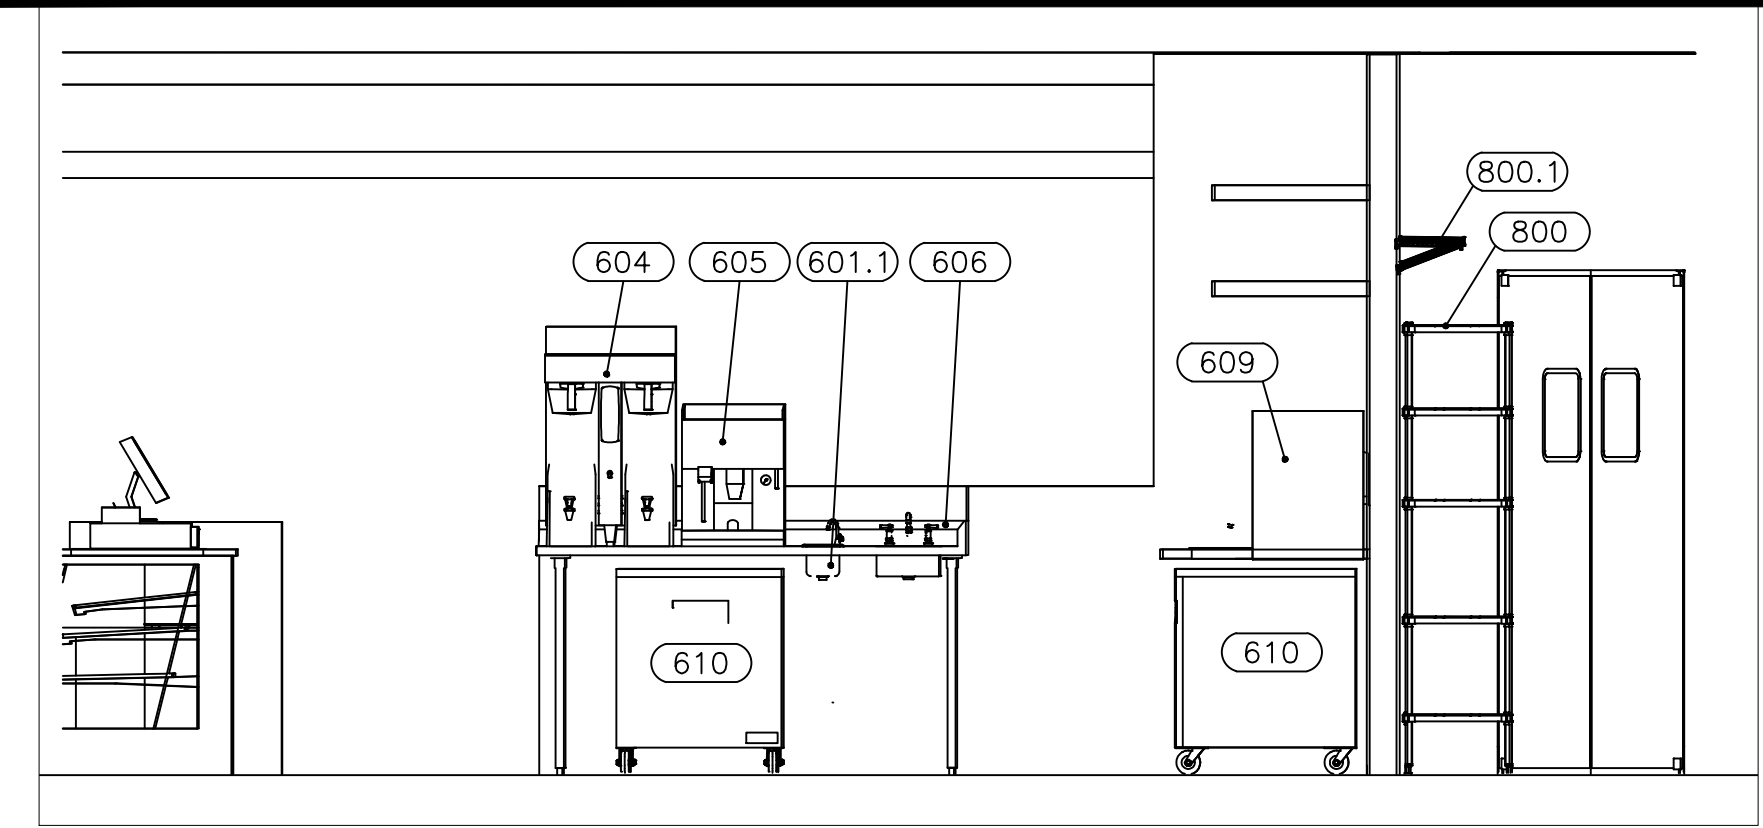


8 BARISTA ELEVATION
K-401 SCALE: 3/8" = 1'-0"

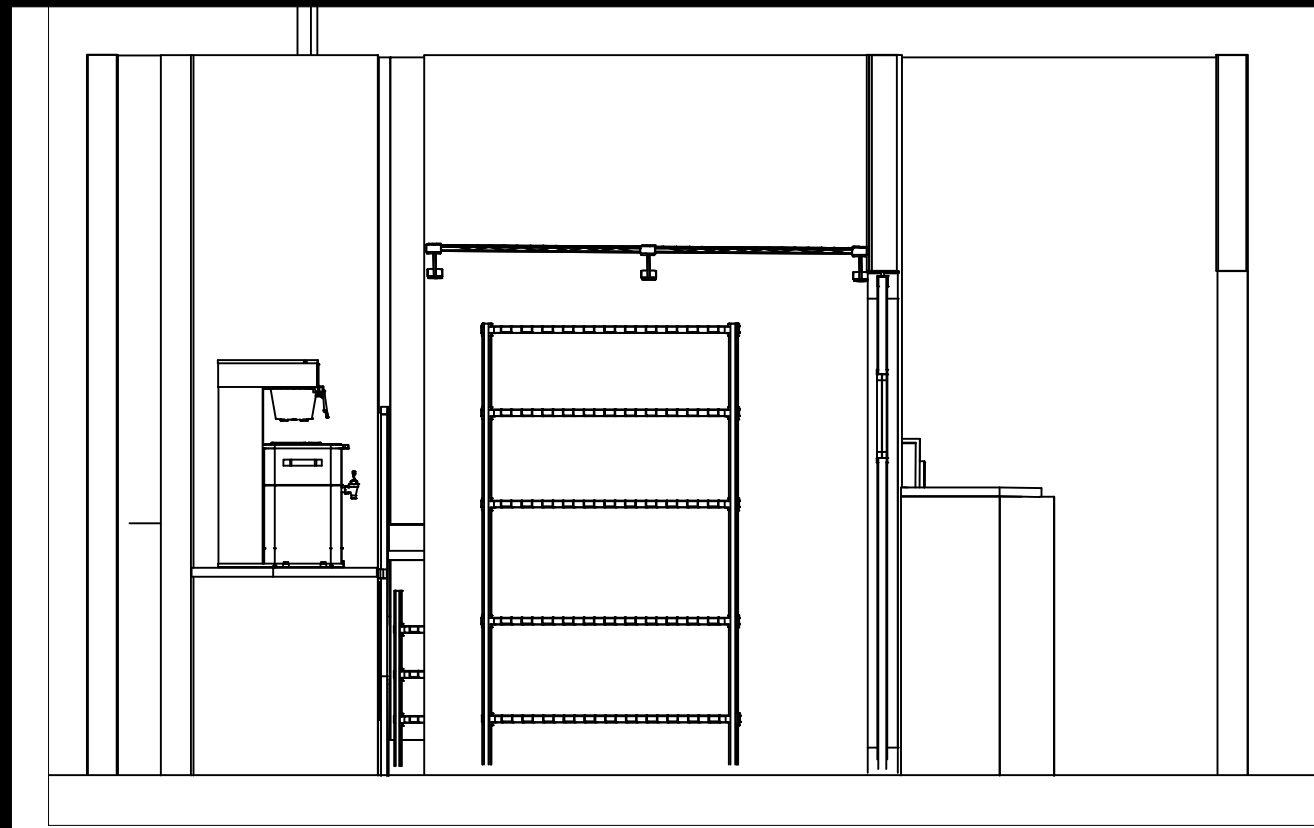


10 DRY STORAGE ELEVATION
K-401 SCALE: 3/8" = 1'-0"

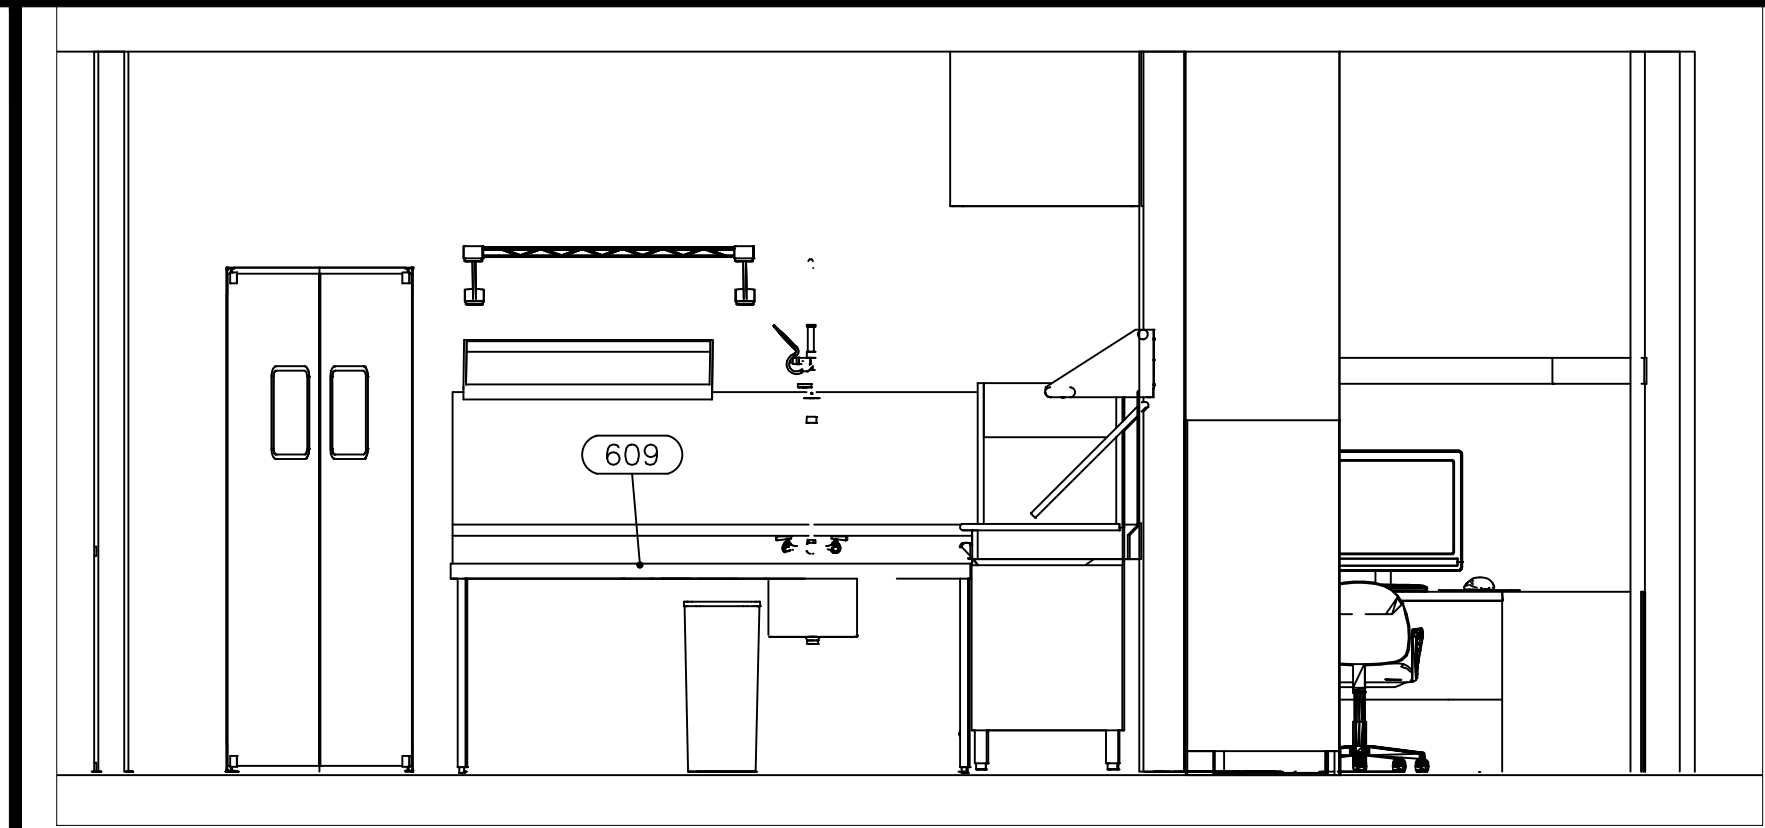


11 SOILED DISH ELEVATION
K-401 SCALE: 3/8" = 1'-0"

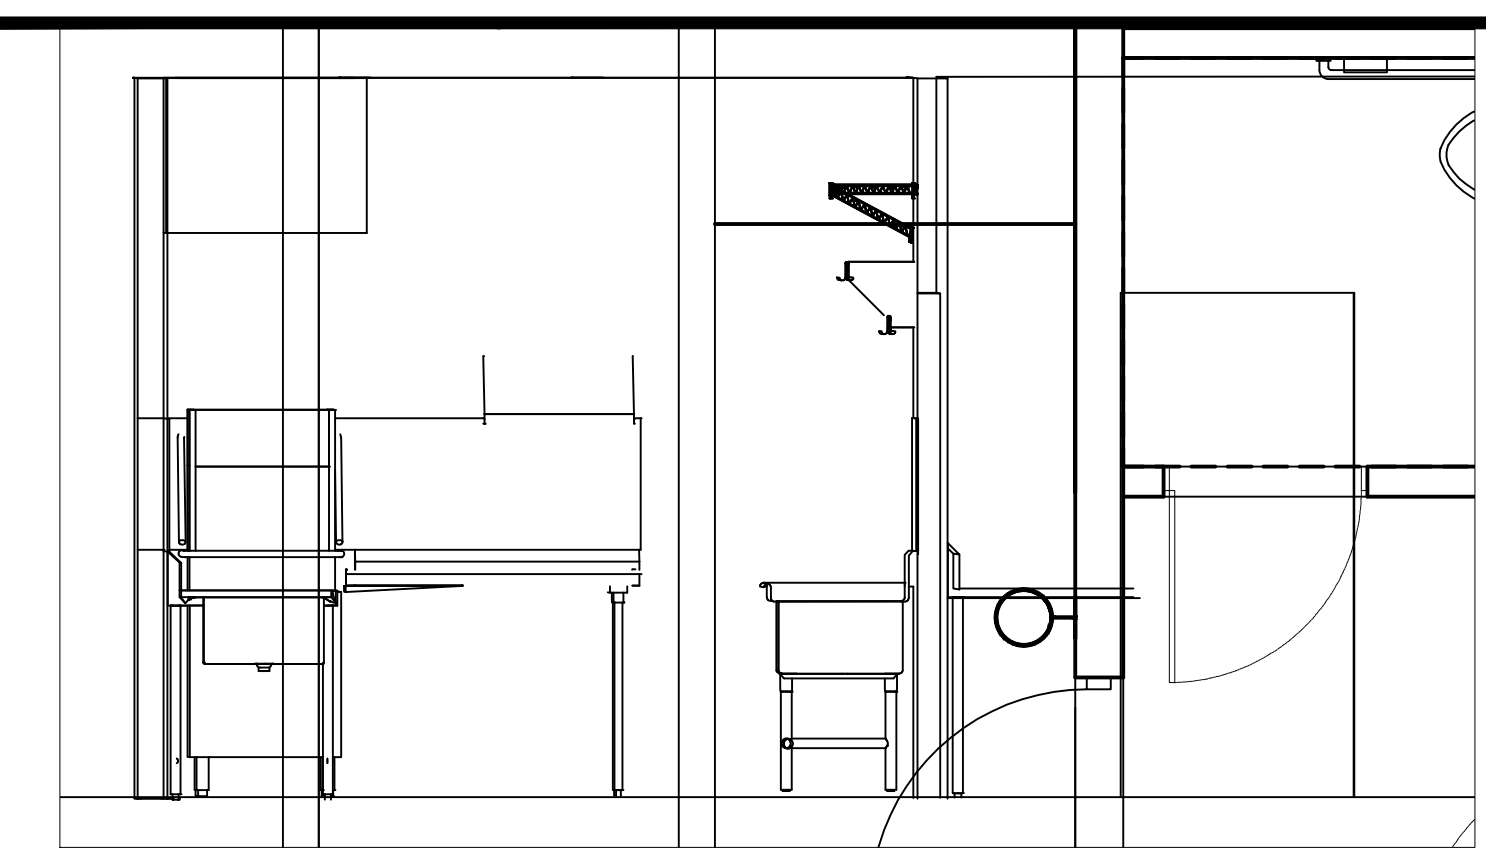


12 CLEAN DISH ELEVATION
K-401 SCALE: 3/8" = 1'-0"

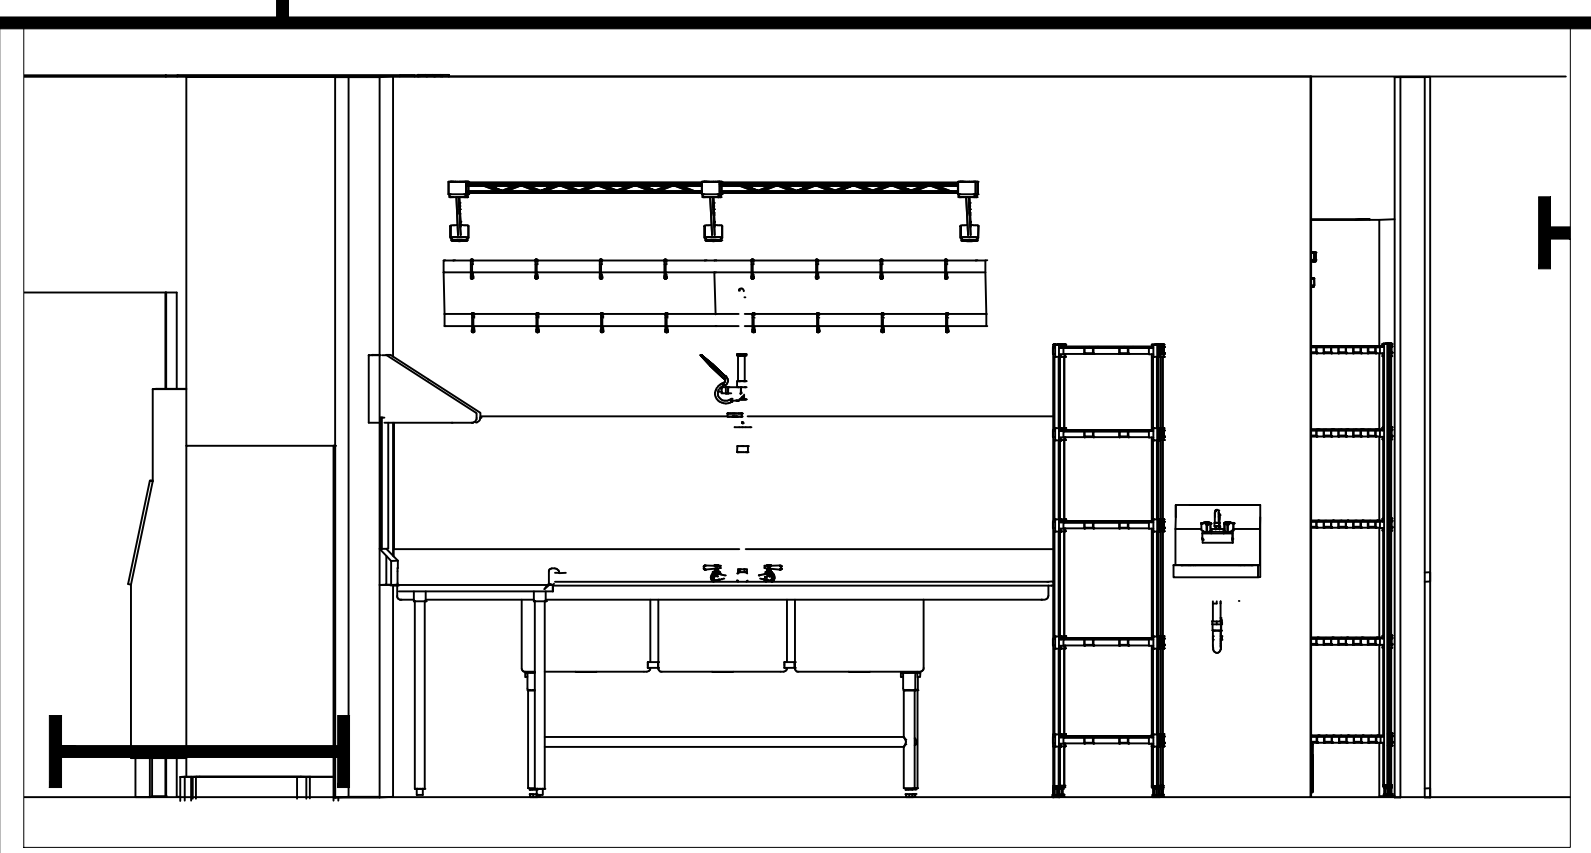

13 3-BOWL SINK ELEVATION
K-401 SCALE: 3/8" = 1'-0"

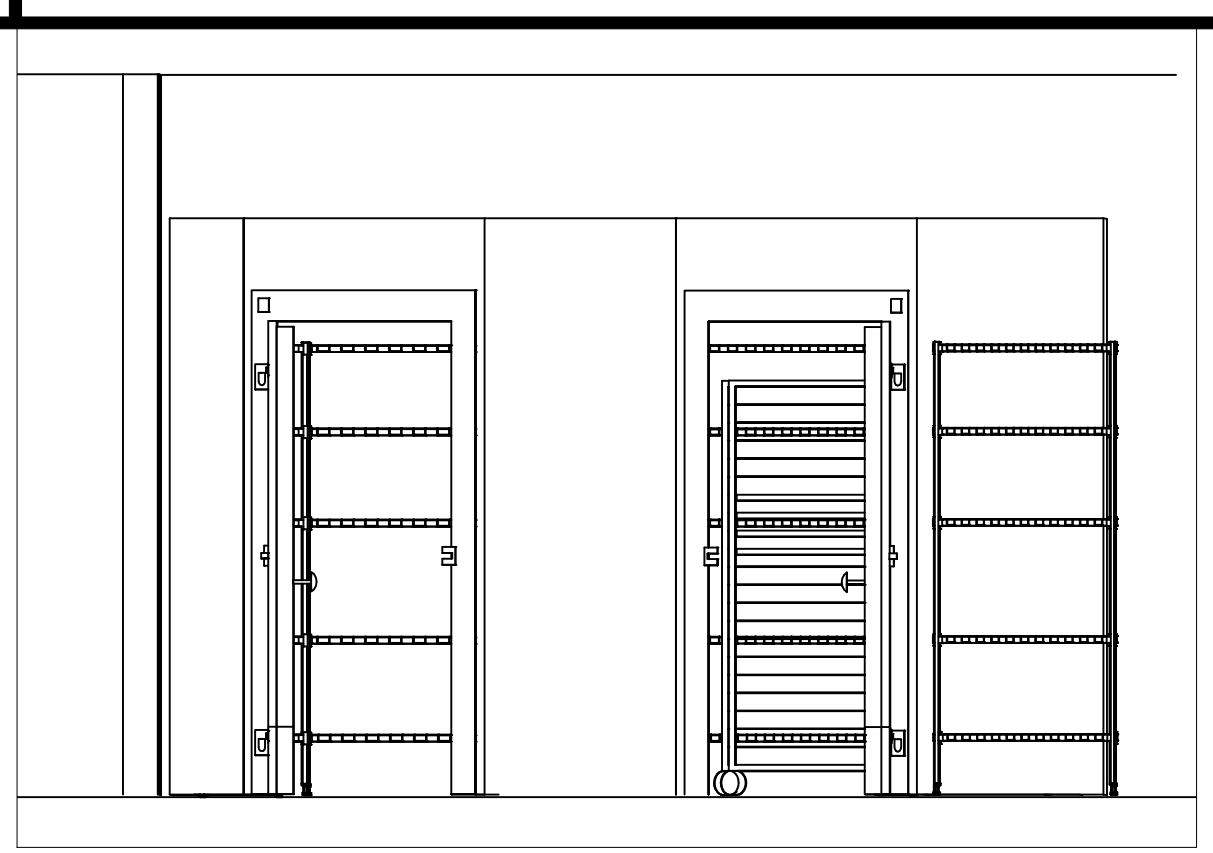

14 WALK-IN COOLER/FREEZER
K-401 SCALE: 3/8" = 1'-0"

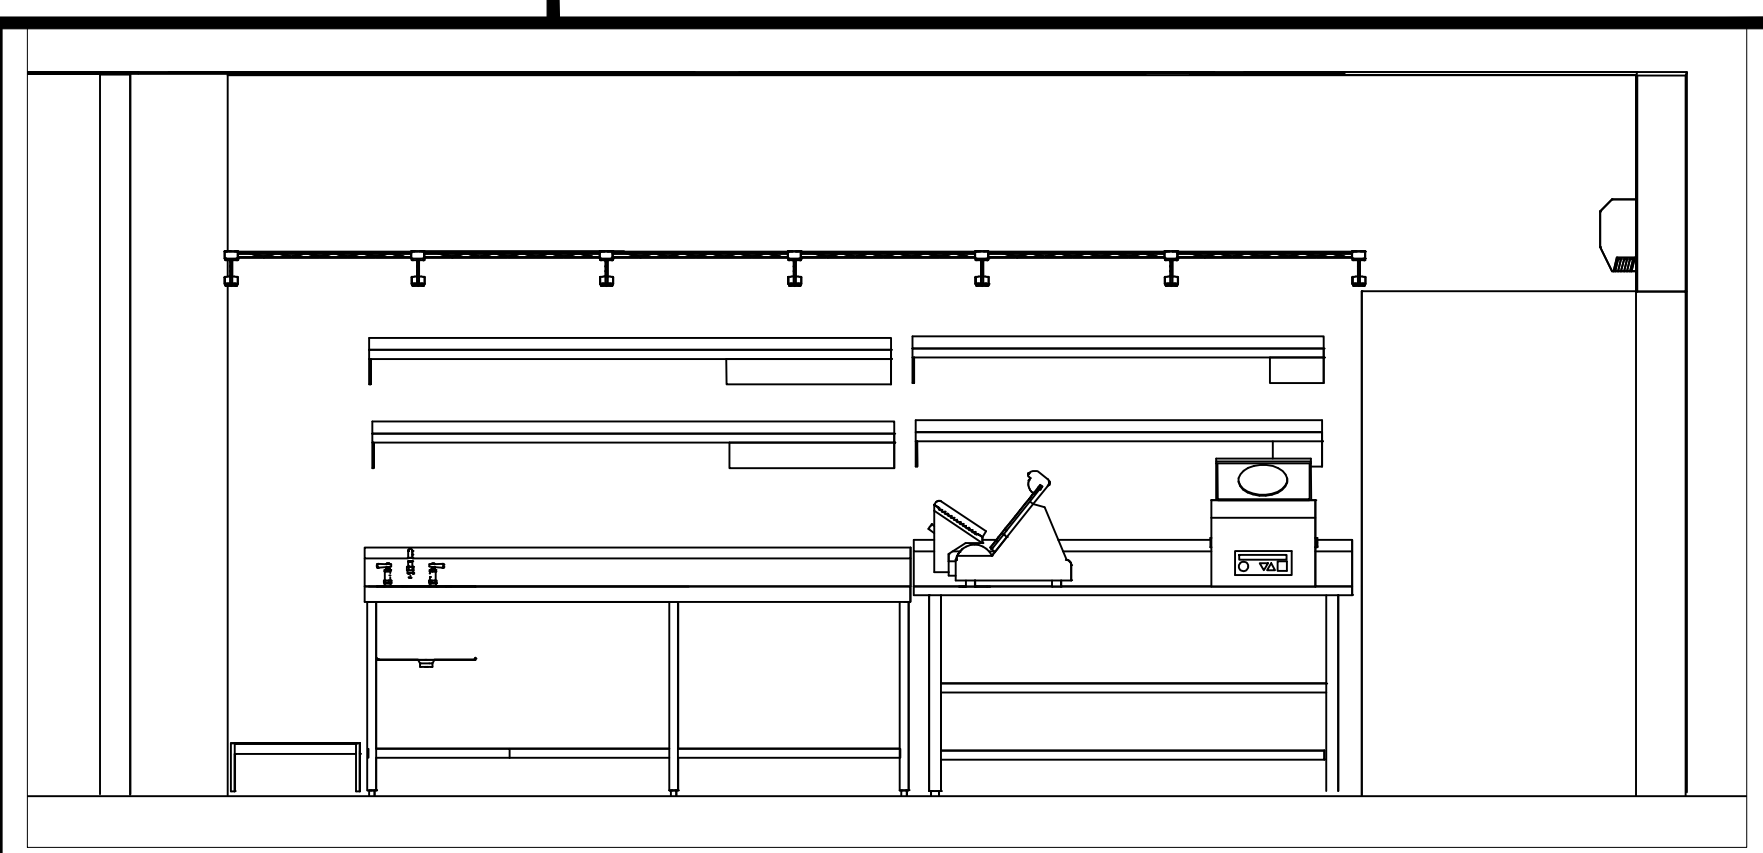

15 PREP STATION ELEVATION
K-401 SCALE: 3/8" = 1'-0"

THESE DRAWINGS ARE THE PROPERTY OF N. WASSERSTROM & SONS, INC. AND IS TO REMAIN IN THE POSSESSION OF OUR REPRESENTATIVE. UNLESS PERMISSION IS GIVEN BY N. WASSERSTROM & SONS, INC. YOU MUST BE SEPARATED FROM THESE DRAWINGS.

FOR REFERENCE ONLY
CAUTION: THESE DRAWINGS ARE FOR REFERENCE ONLY. FINAL RESPONSIBILITY FOR PLUMBING, ELECTRICAL & VENTILATION EQUIPMENT SHALL BE THE RESPONSIBILITY OF THE CONTRACTOR. THESE DRAWINGS ARE NOT LICENSED ARCHITECT OR LICENSED MECHANICAL DRAWERS. THESE DRAWINGS ARE NOT INTENDED TO BE, NOR SHOULD THEY BE USED AS WORKING DRAWINGS. FOR ALL MECHANICAL REQUIREMENTS REFER TO THE APPLICABLE MECHANICAL CODES. WASSERSTROM ASSUMES NO LIABILITY IN PROVIDING THESE DRAWINGS.

AMAIZE

amaize

EQUIPMENT
ELEVATION
PLAN

DATE: 01/29/2014
SCALE: 3/8" = 1'-0"
DRAWN: MJH
DWG. NUMBER: 12120600

SHEET
K-401
1 OF 7 SHEETS

wasserstrom
N. Wasserstrom & Sons
Manufacturers of Quality Products for the Food Marketing Industry
2881 COOKS BLDG. • COVINGTON, LA 70022

